


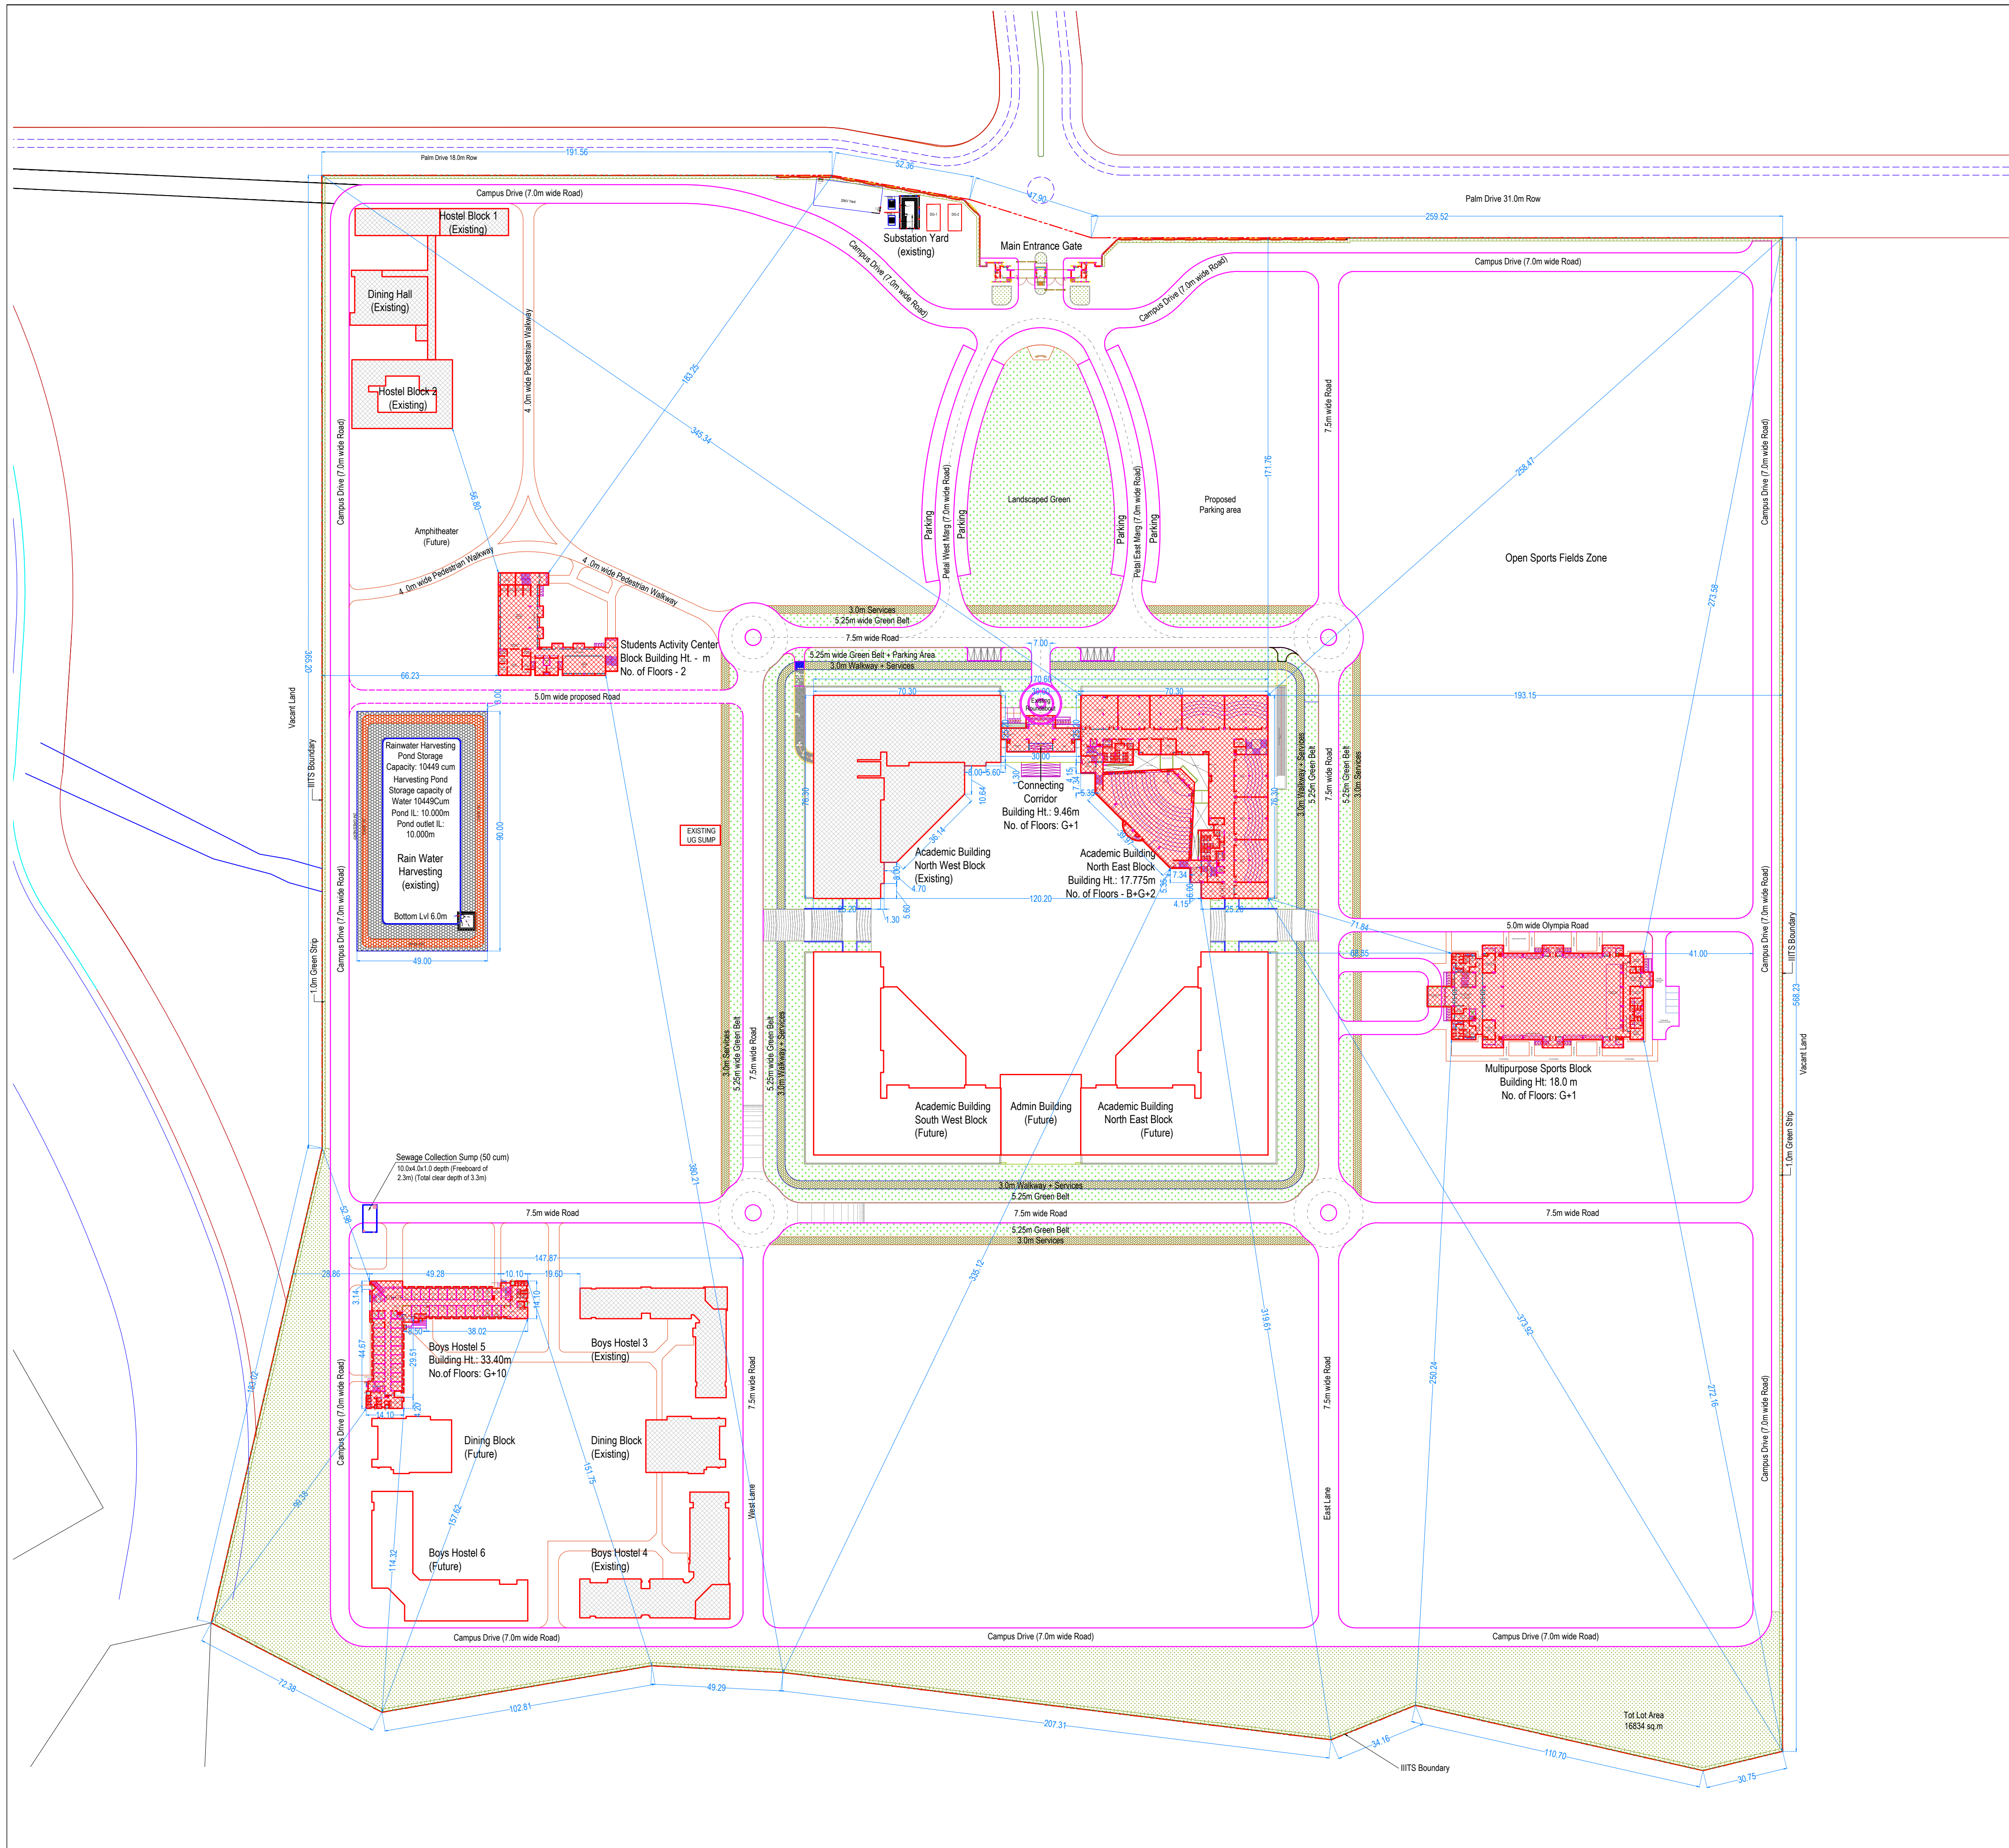

- NOTES:
1. All dimensions are in mm unless noted otherwise.
 2. The dimensions are to be read and not scaled off the drawing.
 3. Any discrepancy in the drawing shall be brought to the notice of the Architects.
 4. This drawing is to be read in conjunction with other relevant drawings & specifications given in the tender document.
 5. Only the latest revision of the drawings shall be considered valid for all purposes.

REVISIONS:		
SL.	DATE	DESCRIPTION
-	-	-
-	-	-
-	-	-
-	-	-
-	-	-
-	-	-
-	-	-
-	-	-

- Existing Buildings
- Proposed Buildings
- Future Buildings
- Landscaped Green
- Site Boundary extents

ELECTRICAL CONSULTANT
SV Intense Engineering Infrastructure Pvt. Ltd.
Velachery, Chennai - 600042

PLUMBING & FIRE-FIGHTING CONSULTANT
Behera & Associates
F-623A, Lado Sarai, Behind CNG Station, New Delhi

HVAC CONSULTANT
Abid Husain Consultants
LG-182, Jeevan Prakash Apartment, 16A, Okhla, New Delhi

STRUCTURAL CONSULTANT
Jehovaking Engineering Consultants Pvt. Ltd.
8th Cross Street, Lakshmi Nagar, Porur, Chennai - 600116

PROJECT
Infrastructure Development at IIIT Sri City
Chittoor

CLIENT
Indian Institute of Information Technology
Sri City, Chittoor

Andhra Pradesh

ARCHITECT
Aadharshila Designs Pvt. Ltd.
B - 4/124, L. G. F., Salfarjung Enclave, New Delhi - 110029.
Tel: +91 11 26100433 - 6, Fax: +91 11 26177678,
E-mail: adpl@adpl.in

COPYRIGHT This drawing is the property of Aadharshila Designs Pvt. Ltd. It shall not be copied, used in any manner and handed over to any person or party without the prior permission of Aadharshila Designs Pvt. Ltd.		
DRAWING TITLE Campus Master Plan		
Existing & Proposed Facilities		
DATE 11.02.2025	SCALE 1:1200 @ A1	REV. R0
DRAWING NO. IIITS / ED / TD /		AR-001

- NOTES:
- All dimensions are in mm unless noted otherwise.
 - The dimensions are to be read and not scaled off the drawing.
 - Any discrepancy in the drawing shall be brought to the notice of the Architects.
 - This drawing is to be read in conjunction with other relevant drawings & specifications given in the tender document.
 - Only the latest revision of the drawings shall be considered valid for all purposes.

REVISIONS:

SL.	DATE	DESCRIPTION
-	-	-
-	-	-
-	-	-
-	-	-
-	-	-
-	-	-
-	-	-

ELECTRICAL CONSULTANT
SV Intense Engineering Infrastructure Pvt. Ltd.
Velachery, Chennai - 600042

PLUMBING & FIRE-FIGHTING CONSULTANT
Behera & Associates
F-623A, Lado Sarai, Behind CNG Station, New Delhi

HVAC CONSULTANT
Abid Husain Consultants
LG-1&2, Jeevan Prakash Apartment, 16A, Okhla, New Delhi

STRUCTURAL CONSULTANT
Jehovaking Engineering Consultants Pvt. Ltd.
6th Cross Street, Lakshmi Nagar, Porur, Chennai - 600116

PROJECT
Infrastructure Development at IIIT Sri City
Chittoor

CLIENT
Indian Institute of Information Technology
Sri City, Chittoor
Andhra Pradesh

ARCHITECT

ADPL
Aadharshila Designs Pvt. Ltd.
B - 4/124, L. G. F., Safdarjung Enclave, New Delhi - 110029.
Tel: +91 11 26100433 - 6, Fax : +91 11 26177678,
E-mail: adpl@adpl.in

COPYRIGHT
This drawing is the property of Aadharshila Designs Pvt. Ltd. It shall not be copied, used in any manner and handed over to any person or party without the prior permission of Aadharshila Designs Pvt. Ltd.

DRAWING TITLE
Site Layout with existing levels


Multipurpose Sports Block

DATE
26.05.2024

SCALE
1:500 @ A2

DRAWING NO.
IIITS / MSB / TD /


A2-LV

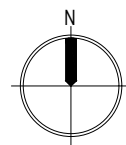


REV.

R0

DETAILED ARCHITECTURAL DRAWINGS (FOR TENDER)

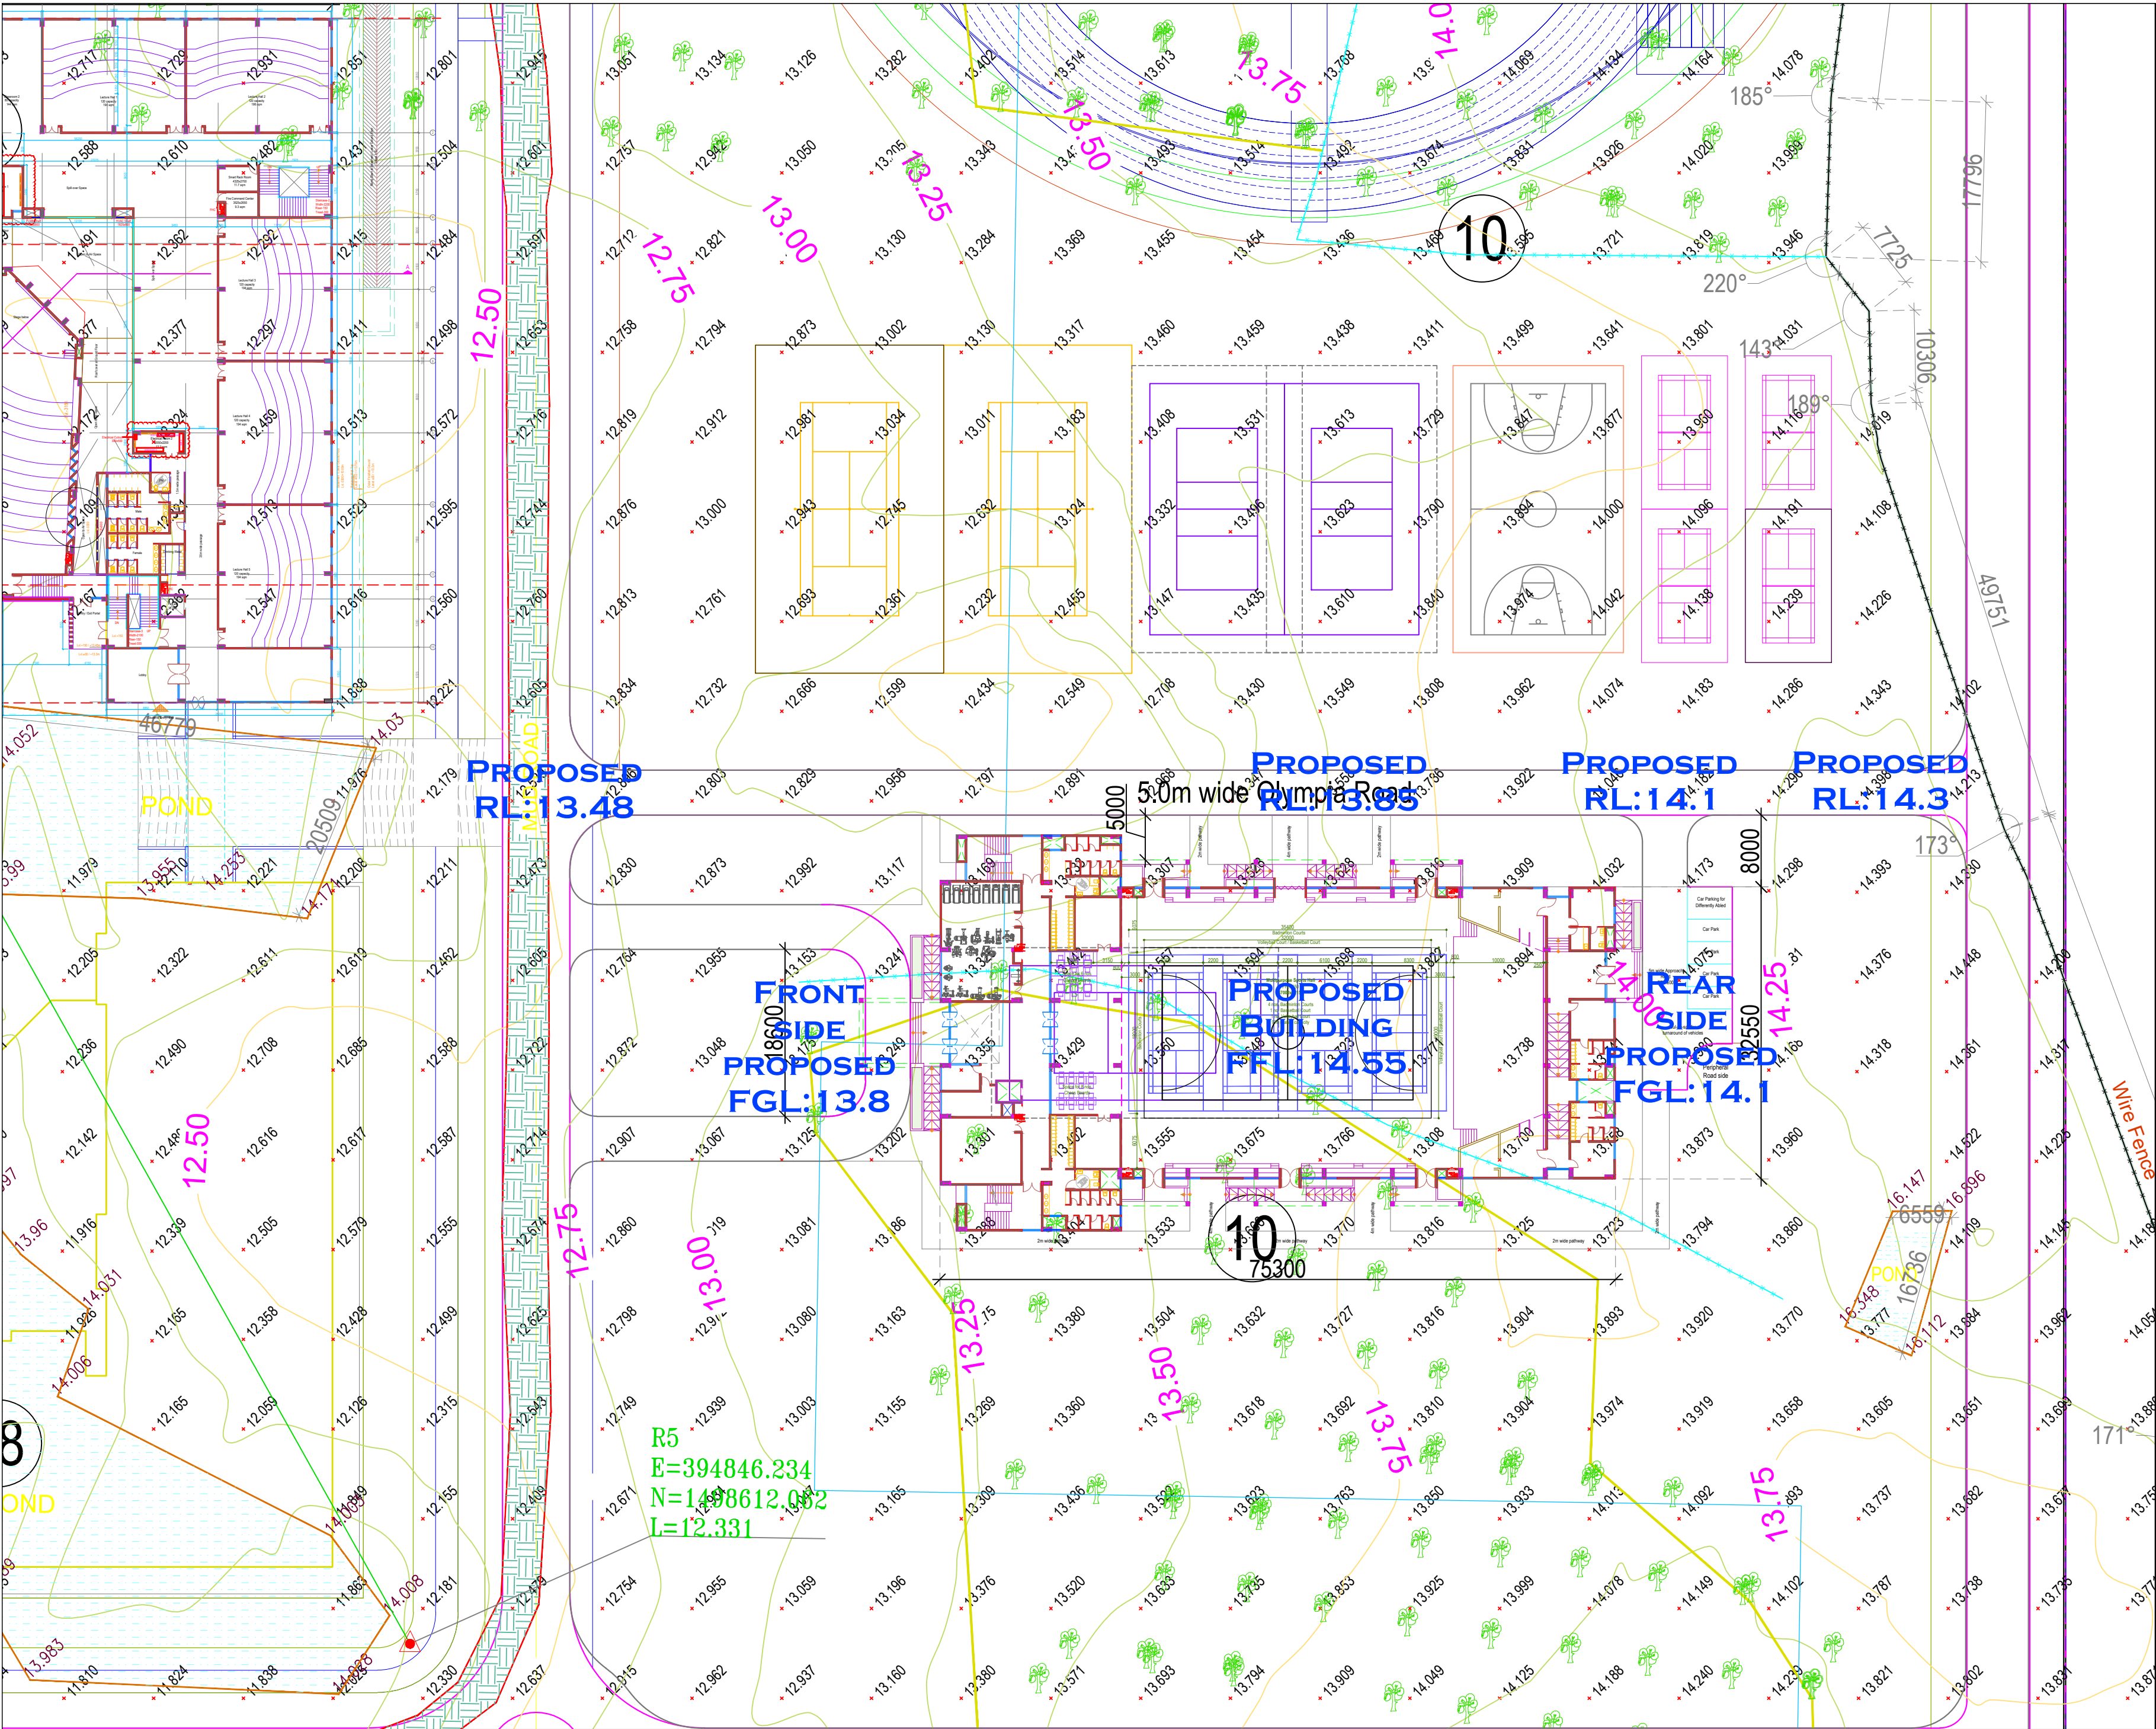


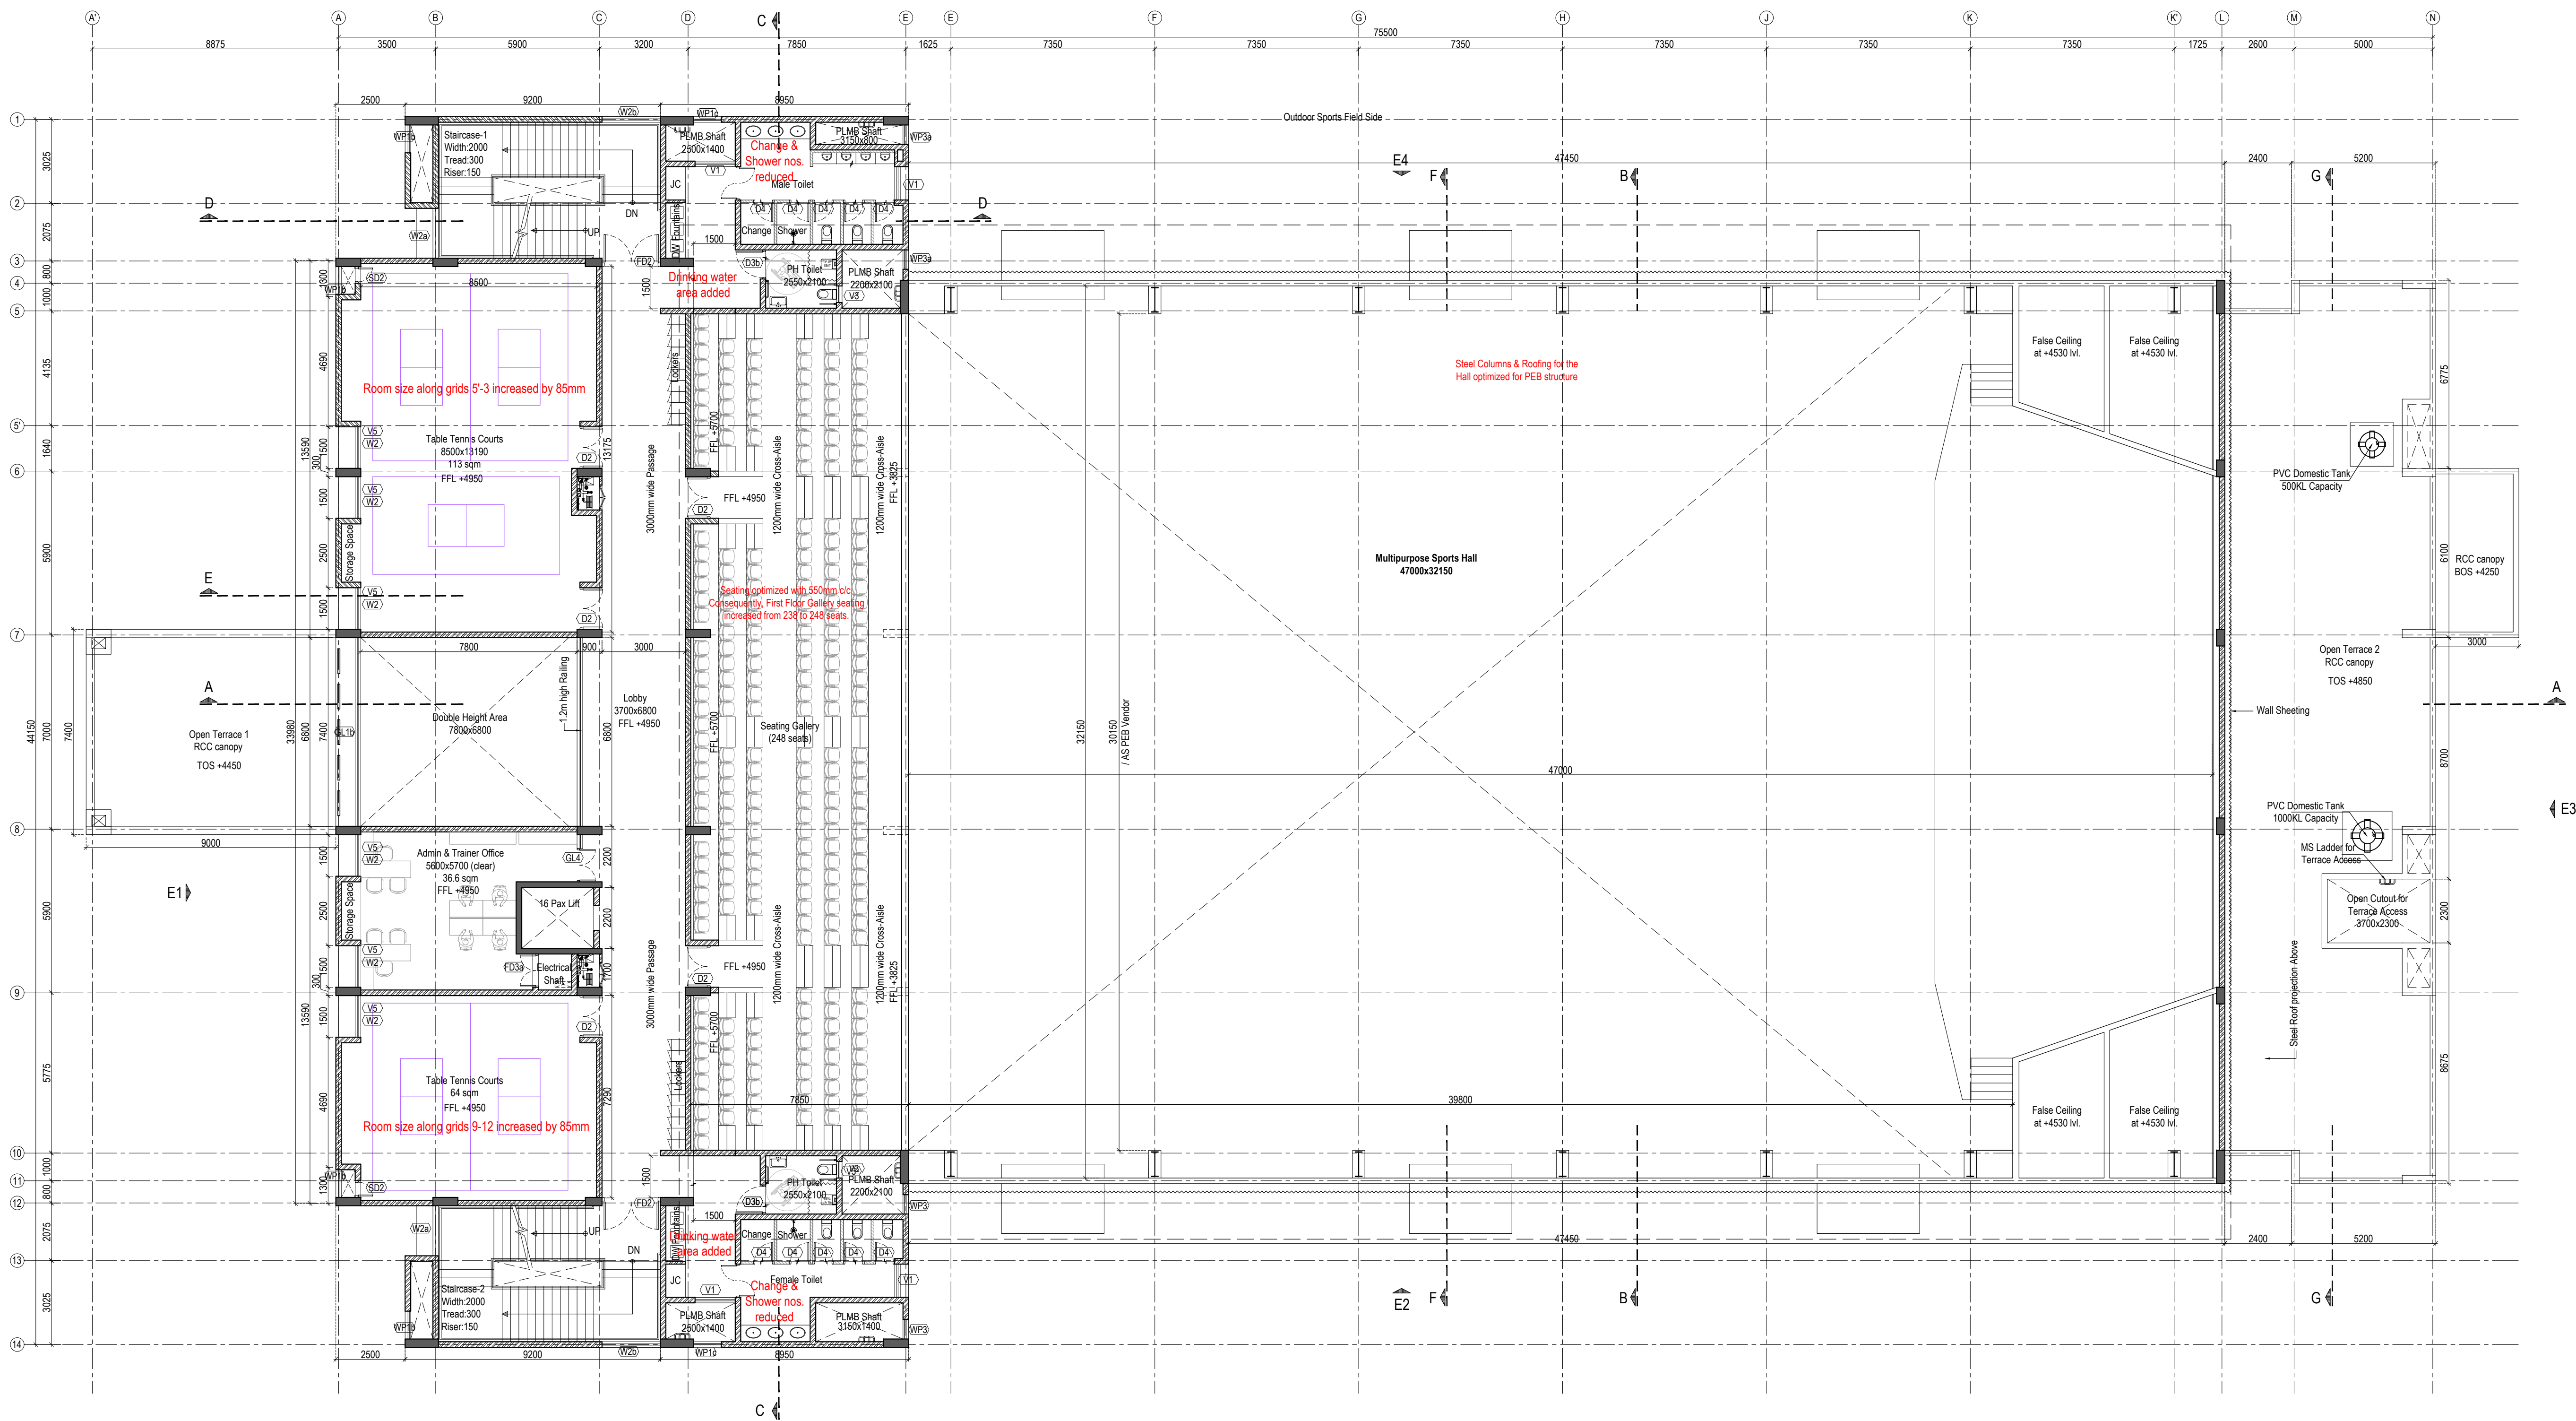

FIRST FLOOR PLAN


DETAILED ARCHITECTURAL DRAWINGS (FOR TENDER)

NOTES: 1. All dimensions are in mm unless noted otherwise. 2. The dimensions are to be read and not scaled off the drawing. 3. Any discrepancy in the drawing shall be brought to the notice of the Architects. 4. This drawing is to be read in conjunction with other relevant drawings & specifications given in the tender document. 5. Only the latest revision of the drawings shall be considered valid for all purposes.	REVISIONS:		ELECTRICAL CONSULTANT SV Intense Engineering Infrastructure Pvt. Ltd. Velachery, Chennai - 600042 PLUMBING & FIRE-FIGHTING CONSULTANT Behera & Associates F-623A, Lado Sarai, Behind CNG Station, New Delhi HVAC CONSULTANT Abid Husain Consultants LG-182, Jeevan Prakash Apartment, 16A, Okhla, New Delhi STRUCTURAL CONSULTANT Jehovaking Engineering Consultants Pvt. Ltd. 6th Cross Street, Lakshmi Nagar, Ponur, Chennai - 600116	PROJECT Infrastructure Development at IIIT Sri City Chittoor CLIENT Indian Institute of Information Technology Sri City, Chittoor Andhra Pradesh	ARCHITECT ADPL Aadharshila Designs Pvt. Ltd. B - 41/24, L. G. F., Salfarjung Enclave, New Delhi - 110029. Tel: +91 11 26100433-6, Fax: +91 11 26177678, E-mail: adpl@adpl.in COPYRIGHT This drawing is the property of Aadharshila Designs Pvt. Ltd. It shall not be copied, used in any manner and handed over to any person or party without the prior permission of Aadharshila Designs Pvt. Ltd.	DRAWING TITLE First Floor Plan Multipurpose Sports Block		REV. R2
	SL.	DATE	DESCRIPTION			DATE	SCALE	
	R1	25.06.2025	Revised as mentioned in drawings			13.06.2025	1:125 @ A1	
	R2	24.09.2025	Revised as mentioned in drawings					
	-	-	-					

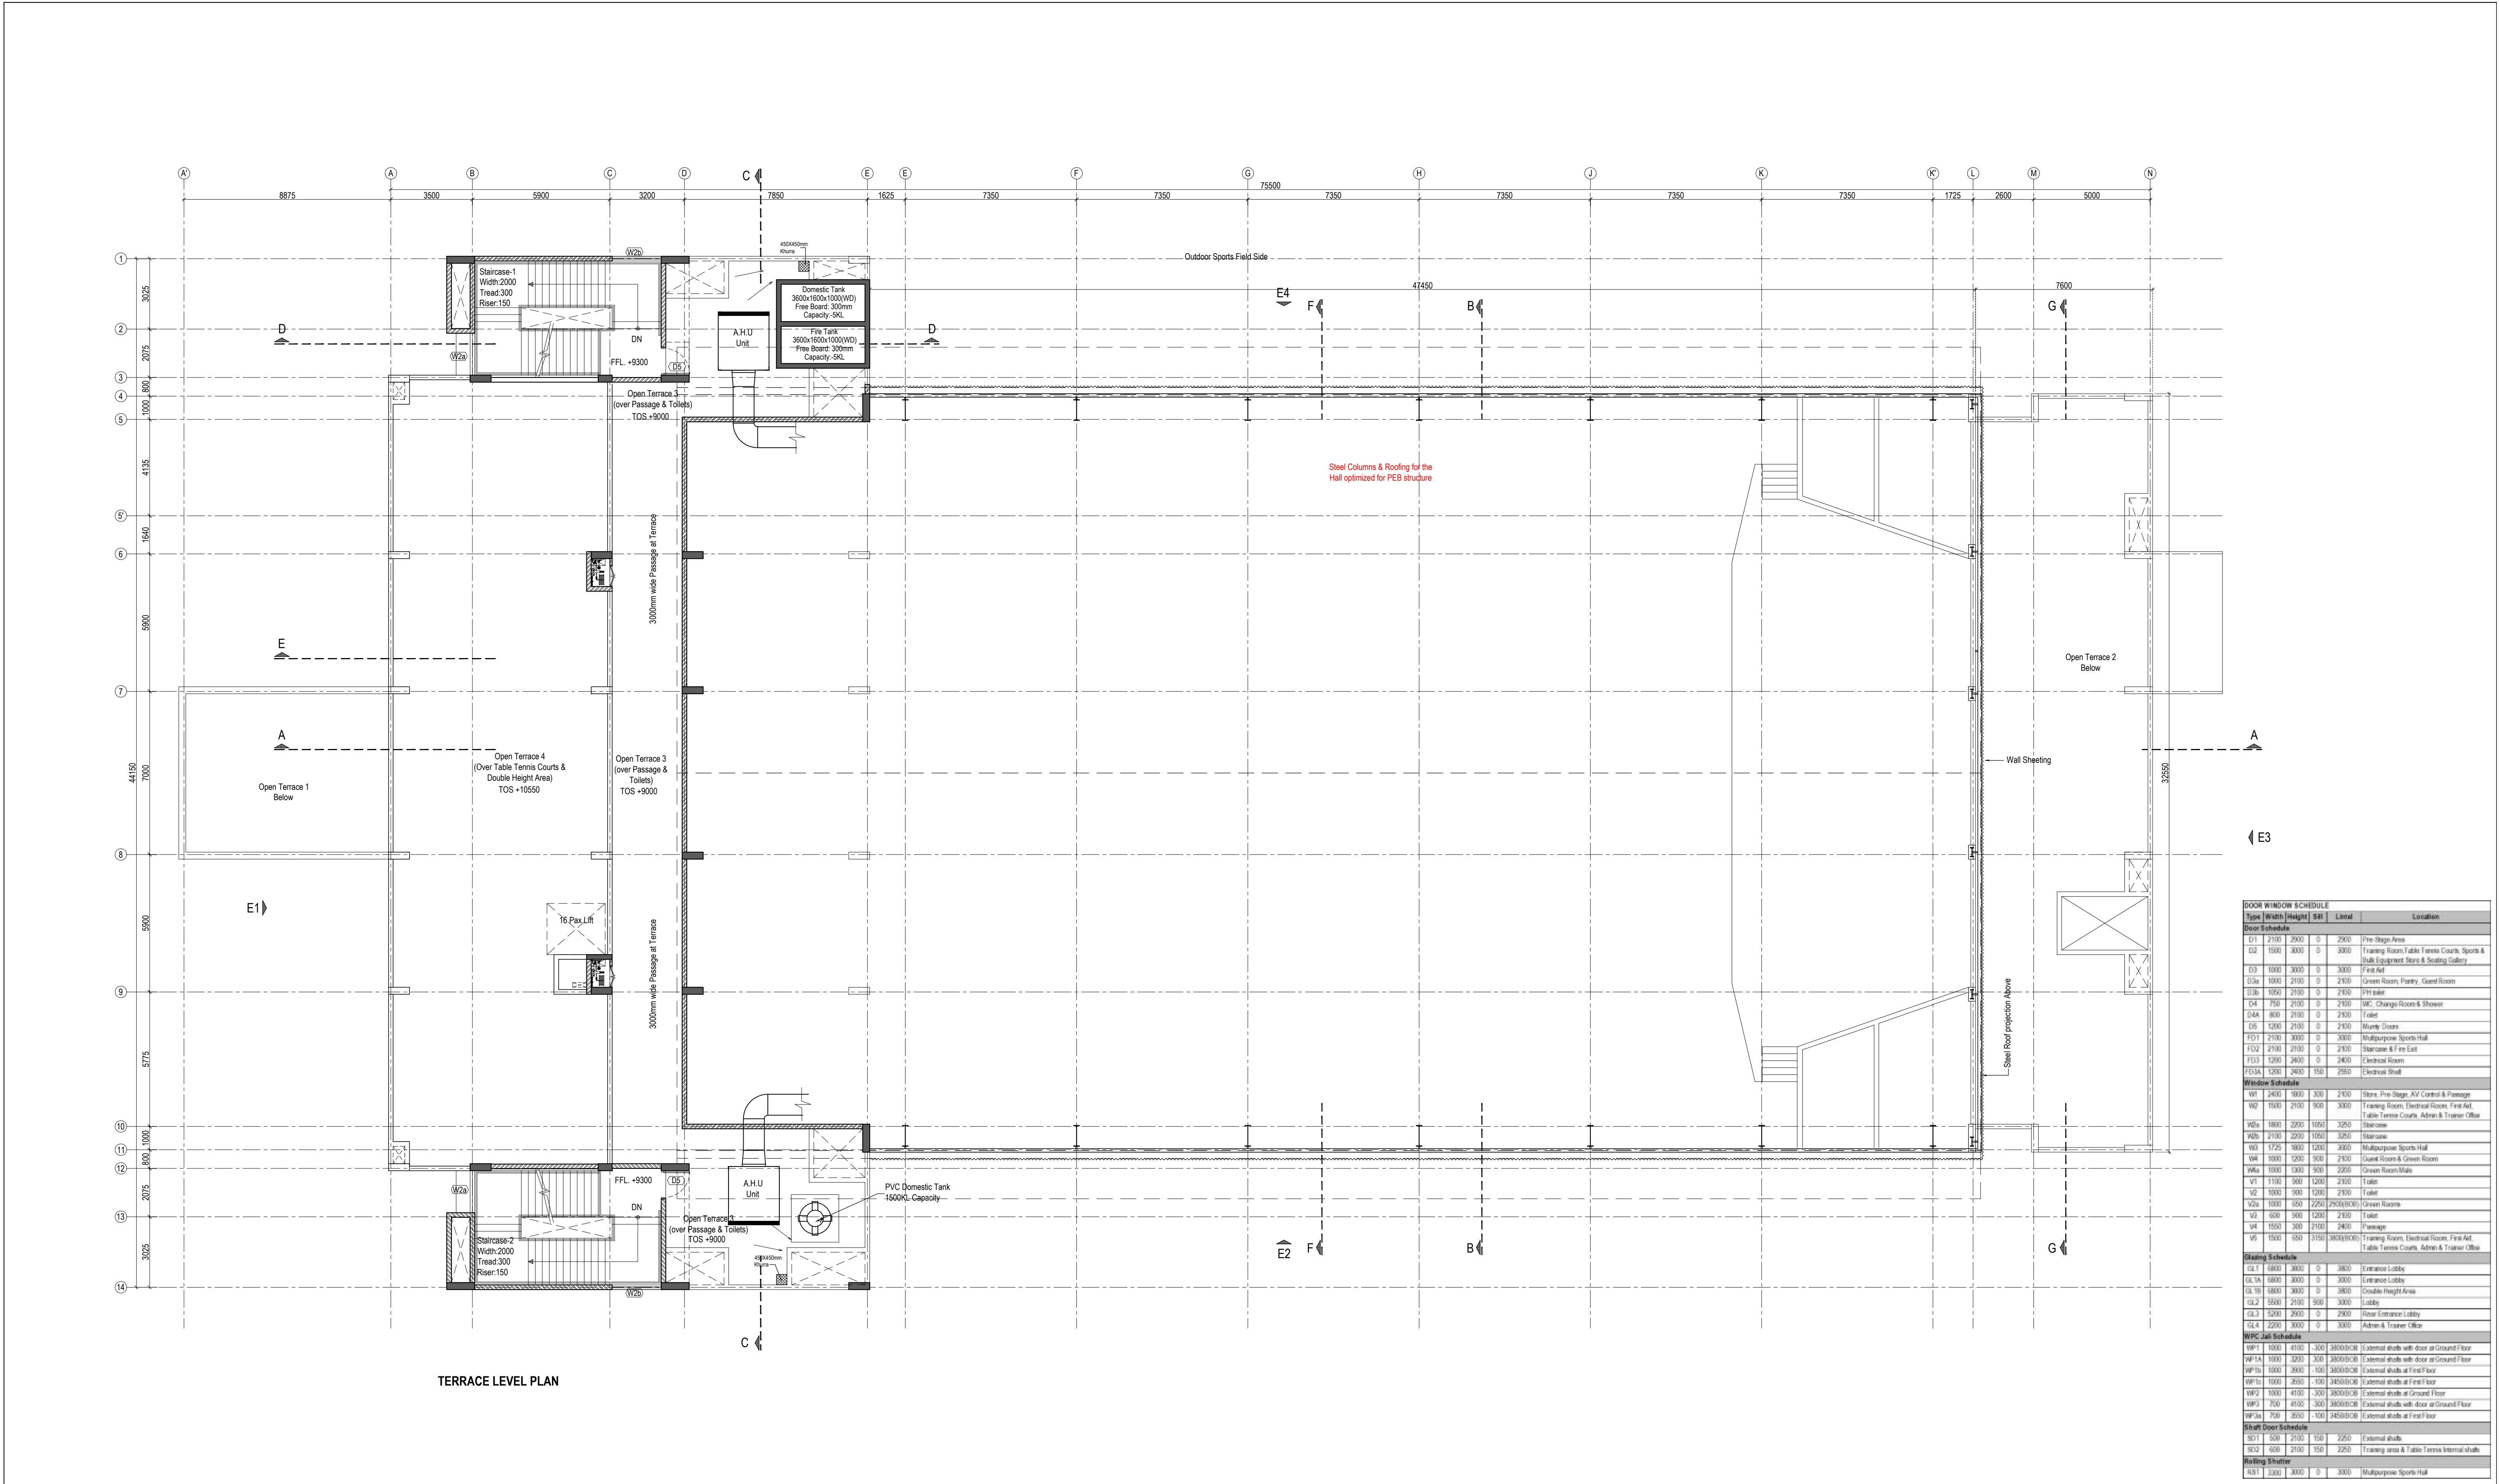

DOOR WINDOW SCHEDULE					
Type	Width	Height	SB	Level	Location
Door Schedule					
D1	2100	2000	0	2500	Pre Stage Area
D2	1500	3000	0	3000	Training Room, Table Tennis Courts, Sports & Bulk Equipment Store & Seating Gallery
D3	1000	3000	0	3000	First Aid
D3a	1000	2100	0	2100	Green Room, Pantry, Guest Room
D3b	1050	2100	0	2100	PH Toilet
D4	750	2100	0	2100	WC, Change Rooms & Showers
D4A	800	2100	0	2100	Toilet
D5	1200	2100	0	2100	Mundy Closets
D11	2100	3000	0	3000	Multipurpose Sports Hall
D12	2100	2100	0	2100	Staircase & Fire Exit
D13	1200	2400	0	2400	Electrical Room
D13A	1200	2400	150	2500	Electrical Shaft
Window Schedule					
W1	2400	1800	300	2100	Store, Pre-Stage, AV Control & Passage
W2	1500	2100	900	3000	Training Room, Electrical Room, First Aid, Table Tennis Courts, Admin & Trainer Office
W2b	1800	2200	1050	3250	Staircase
W3	1725	1800	1200	3000	Multipurpose Sports Hall
W4	1000	1200	900	2100	Guest Room & Green Room
W4a	1000	1300	900	2250	Green Room Male
W1	1100	900	1200	2100	Toilet
W2	1000	900	1200	2100	Toilet
W2a	1000	900	1200	2100	Green Room
W3	600	900	1200	2100	Toilet
W4	1500	300	2100	2400	Passage
W5	1500	900	3150	3800(3500)	Training Room, Electrical Room, First Aid, Table Tennis Courts, Admin & Trainer Office
Shading Schedule					
SL1	6800	3000	0	3800	Entrance Lobby
SL1A	6800	3000	0	3000	Entrance Lobby
SL1B	6800	3000	0	3800	Double Height Area
SL2	5500	2100	500	3000	Lobby
SL3	5200	2500	0	2500	Store Entrance Lobby
SL4	2200	3000	0	3000	Admin & Trainer Office
WPC Jar Schedule					
WPF1	1000	4100	-500	3800(3500)	External shade with door at Ground Floor
WPF1A	1000	3200	300	3800(3500)	External shade with door at Ground Floor
WPF1b	1000	3000	-100	3800(3500)	External shade at First Floor
WPF1c	850	100	100	3450(3100)	External shade at First Floor
WPF2	1000	4100	-500	3800(3500)	External shade at Ground Floor
WPF3	700	4100	-500	3800(3500)	External shade with door at Ground Floor
WPF3a	700	3500	-100	3450(3100)	External shade at First Floor
Shade Door Schedule					
SD1	500	2100	150	2250	External shade
SD2	600	2100	150	2250	Training area & Table Tennis Internal shade
Rolling Shutter					
RST1	3000	3000	0	3000	Multipurpose Sports Hall

NOTES:			REVISIONS:			ELECTRICAL CONSULTANT			PROJECT			ARCHITECT			DETAILED ARCHITECTURAL DRAWINGS (FOR TENDER)		
1.	All dimensions are in mm unless noted otherwise.		SL	DATE	DESCRIPTION		SV Intense Engineering Infrastructure Pvt. Ltd.		Infrastructure Development at IIIT Sri City						Terrace Level Plan		
2.	The dimensions are to be read and not scaled off the drawing.		R1	25.06.2025	Revised as mentioned in drawings		Velachery, Chennai - 600042		Chittoor						Multipurpose Sports Block		
3.	Any discrepancy in the drawing shall be brought to the notice of the Architects.		R2	24.09.2025	Revised as mentioned in drawings		PLUMBING & FIRE-FIGHTING CONSULTANT								DATE		
4.	This drawing is to be read in conjunction with other relevant drawings & specifications given in the tender document.		-	-	-		Behera & Associates								SCALE		
5.	Only the latest revision of the drawings shall be considered valid for all purposes.		-	-	-		F-623A, Lado Sarai, Behind CNG Station, New Delhi								1:125 @ A1		
			-	-	-		HVAC CONSULTANT		CLIENT						DRAWING NO.		
			-	-	-		Abid Husain Consultants		Indian Institute of Information Technology						IIITS / MSB / TD /		
			-	-	-		LG-182, Jeevan Prakash Apartment, 16A, Okhla, New Delhi		Sri City, Chittoor						AR-103		
			-	-	-		STRUCTURAL CONSULTANT		Andhra Pradesh						REV.		
			-	-	-		Jehovaking Engineering Consultants Pvt. Ltd.								R2		
			-	-	-		6th Cross Street, Lakshmi Nagar, Ponur, Chennai - 600116										

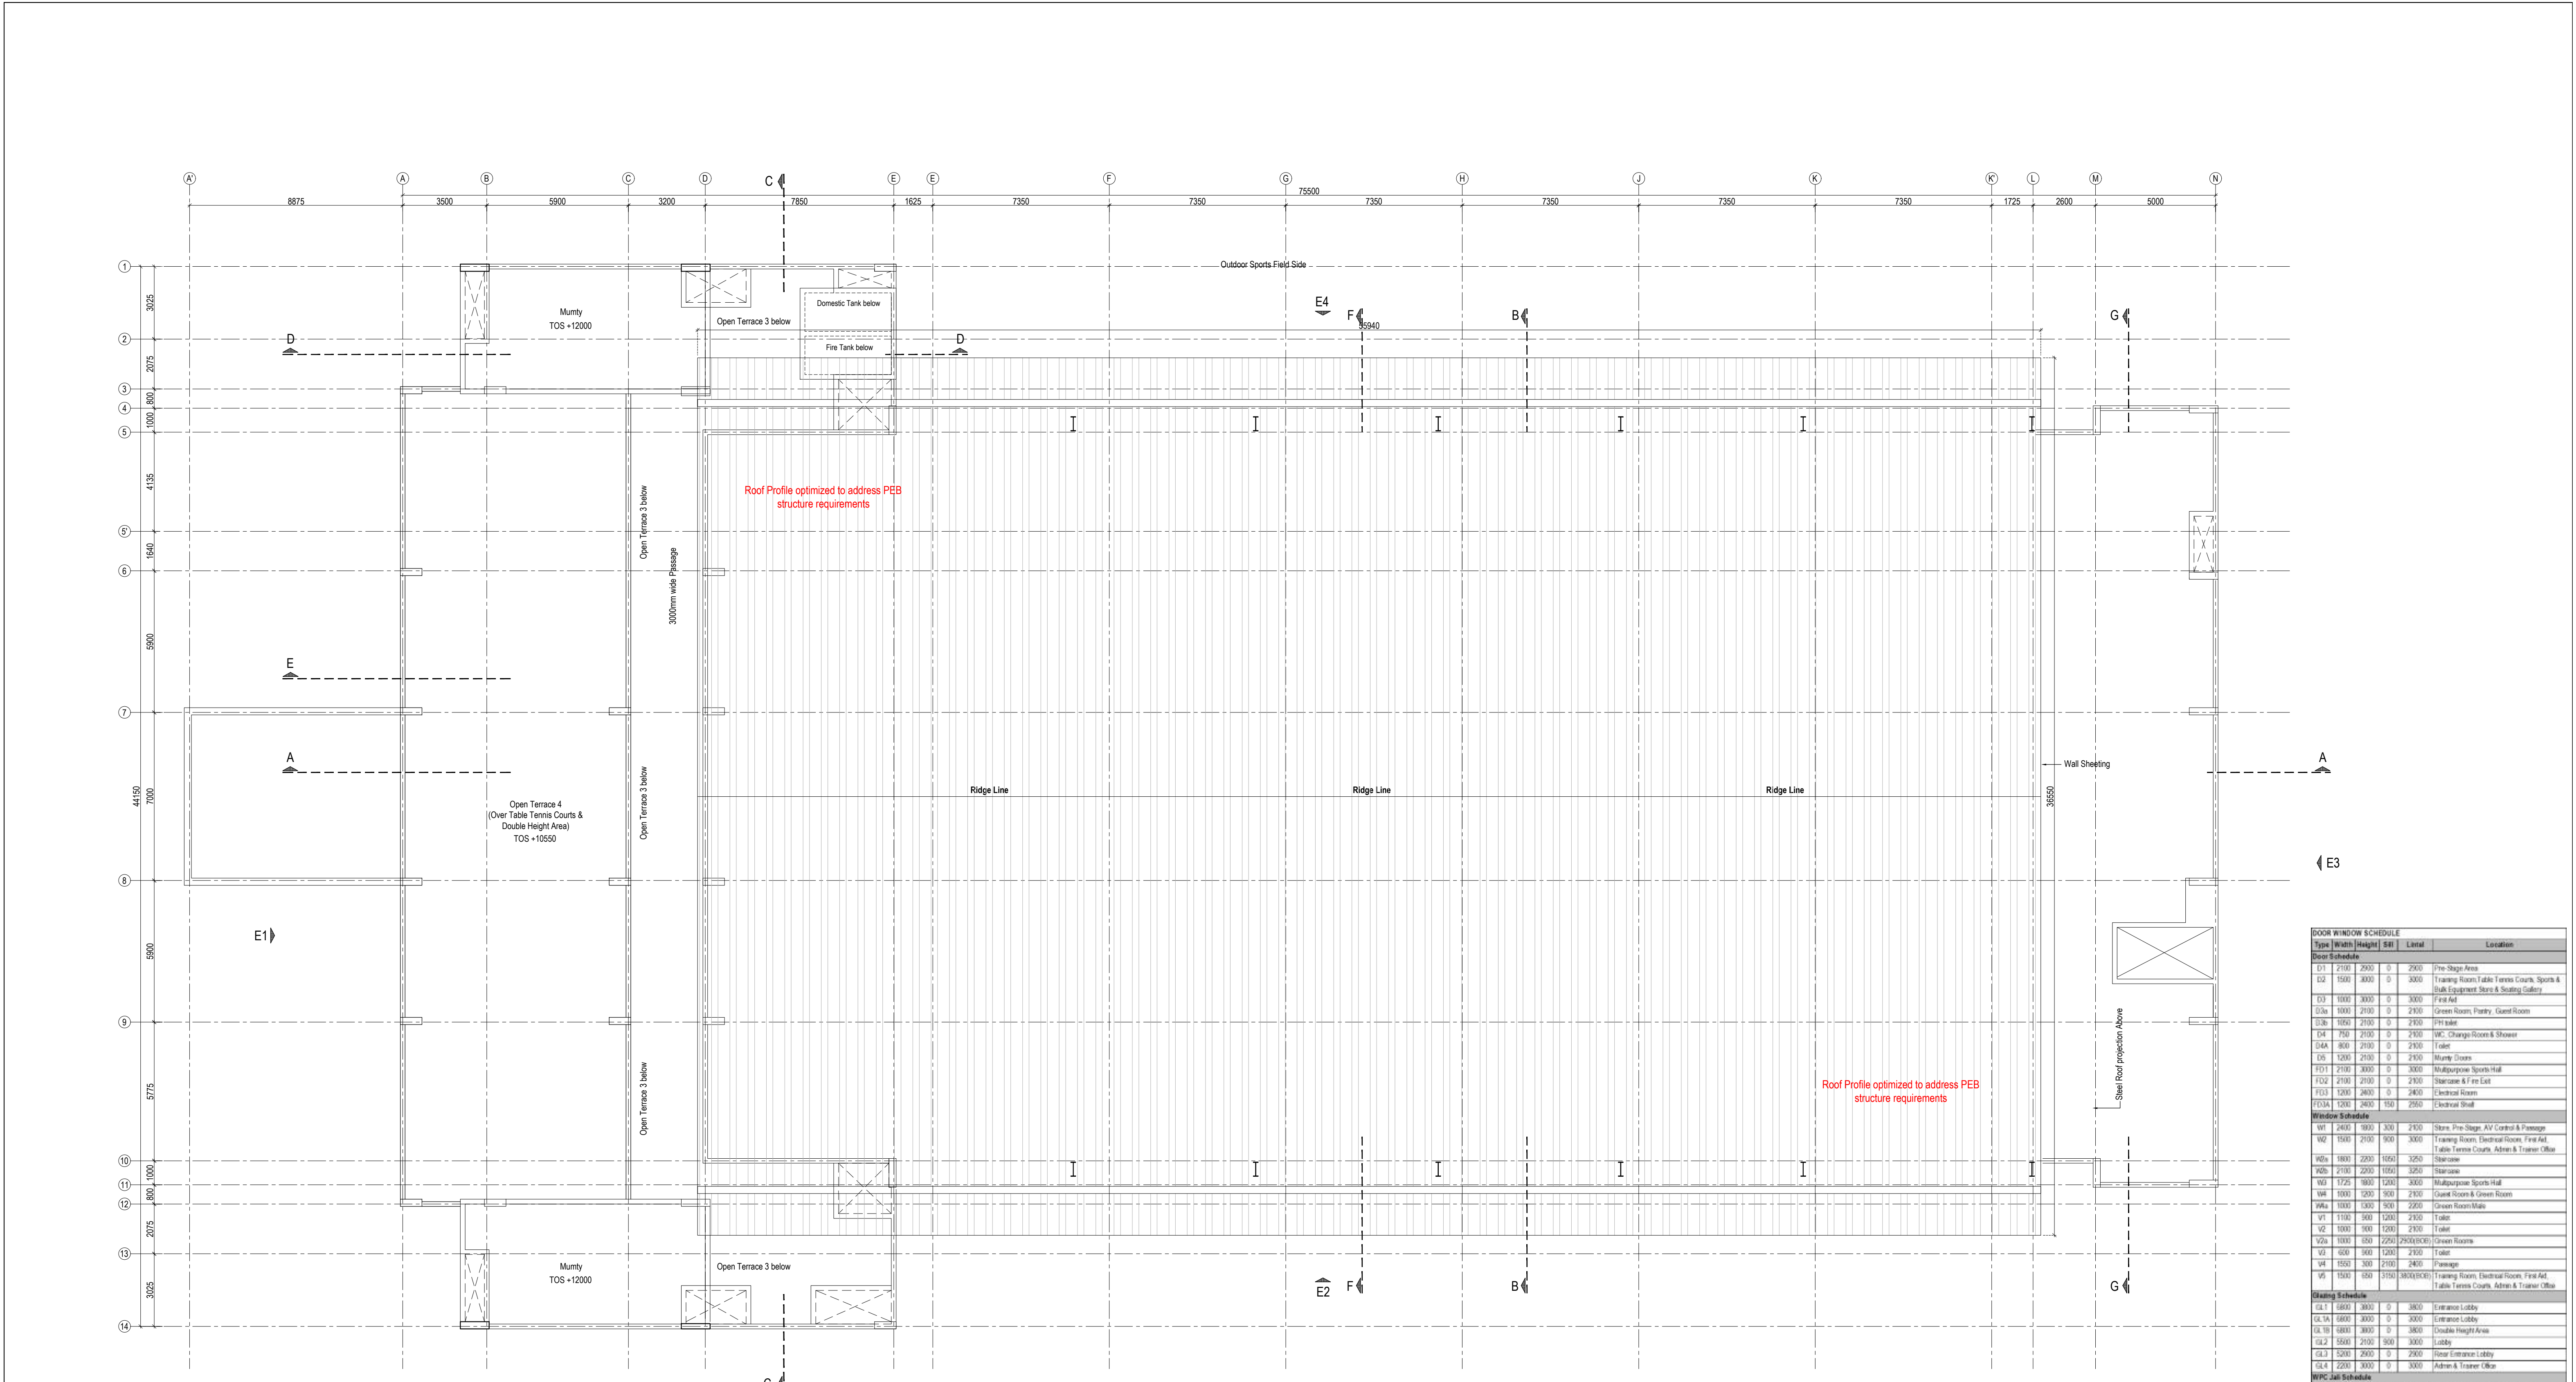


TOP LEVEL PLAN

DOOR WINDOW SCHEDULE					
Type	Width	Height	SB	Level	Location
Door Schedule					
D1	2100	2000	0	2500	Pre Stage Area
D2	1500	3000	0	3000	Training Room, Table Tennis Courts, Sports & Bulk Equipment Store & Seating Gallery
D3	1000	3000	0	3000	First Aid
D3a	1000	2100	0	2100	Green Room, Pantry, Guest Room
D3b	1000	2100	0	2100	First Aid
D4	750	2100	0	2100	WC, Change Rooms & Showers
D4A	800	2100	0	2100	Tablet
D5	1200	2100	0	2100	Mummy Closets
D11	2100	3000	0	3000	Multipurpose Sports Hall
D12	2100	2100	0	2100	Staircase & Fire Exit
D13	1200	2400	0	2400	Electrical Room
D13A	1200	2400	150	2500	Electrical Room
Window Schedule					
W1	2400	1800	300	2100	Store, Pre Stage, AV Control & Passage
W2	1500	2100	900	3000	Training Room, Electrical Room, First Aid, Table Tennis Courts, Admin & Trainer Office
W2a	1800	2200	1050	3250	Staircase
W2b	2100	2200	1050	3250	Staircase
W3	1725	1800	1200	3000	Multipurpose Sports Hall
W4	1000	1200	900	2100	Guest Room & Green Room
W4a	1000	1300	900	2250	Green Room Male
W1	1100	900	1200	2100	Tablet
W2	1000	900	1200	2100	Tablet
W2a	1000	900	1200	2100	Green Room
W3	600	900	1200	2100	Tablet
W4	1500	300	2100	2400	Passage
W5	1500	900	3150	3800(3500)	Training Room, Electrical Room, First Aid, Table Tennis Courts, Admin & Trainer Office
Shading Schedule					
SL1	6800	3000	0	3800	Entrance Lobby
SL1A	6800	3000	0	3000	Entrance Lobby
SL1B	6800	3000	0	3800	Double Height Area
SL2	5500	2100	500	3000	Lobby
SL3	5200	2500	0	2500	Store Entrance Lobby
SL4	2200	3000	0	3000	Admin & Trainer Office
WPC Jali Schedule					
WPC1	1000	4100	-500	3800(3500)	External shade with door at Ground Floor
WPC1A	1000	3200	-500	3800(3500)	External shade with door at Ground Floor
WPC1b	1000	3000	-100	3800(3500)	External shade at First Floor
WPC1c	1000	2500	-100	3800(3500)	External shade at First Floor
WPC2	1000	4100	-500	3800(3500)	External shade at Ground Floor
WPC2a	700	4100	-500	3800(3500)	External shade with door at Ground Floor
WPC3a	700	3500	-100	3800(3500)	External shade at First Floor
Shade Door Schedule					
SD1	500	2100	150	2250	External shade
SD2	600	2100	150	2250	Training area & Table Tennis Internal shade
Rolling Shutter					
RS1	3000	3000	0	3000	Multipurpose Sports Hall

DETAILED ARCHITECTURAL DRAWINGS (FOR TENDER)

NOTES:			REVISIONS:			PROJECT			ARCHITECT			DRAWING TITLE		
1.	All dimensions are in mm unless noted otherwise.		SL	DATE	DESCRIPTION	ELECTRICAL CONSULTANT			ADPL			Top Level Plan		
2.	The dimensions are to be read and not scaled off the drawing.		R1	25.06.2025	Revised as mentioned in drawings	SV Intense Engineering Infrastructure Pvt. Ltd.			Aadharshila Designs Pvt. Ltd.			Multipurpose Sports Block		
3.	Any discrepancy in the drawing shall be brought to the notice of the Architects.		R2	24.09.2025	Revised as mentioned in drawings	PLUMBING & FIRE-FIGHTING CONSULTANT			B - 41/24, L. G. F., Salfarjung Enclave, New Delhi - 110029.			DATE		
4.	This drawing is to be read in conjunction with other relevant drawings & specifications given in the tender document.		-	-	-	Behera & Associates			Tel : +91 11 26104533-6, Fax : +91 11 261177678,			SCALE		
5.	Only the latest revision of the drawings shall be considered valid for all purposes.		-	-	-	F-623A, Lado Sarai, Behind CNG Station, New Delhi			E-mail : adpl@adpl.in			1:125 @ A1		
						HVAC CONSULTANT			CLIENT			DRAWING NO.		
						Abid Husain Consultants			Indian Institute of Information Technology			IIITS / MSB / TD /		
						LG-182, Jeevan Prakash Apartment, 16A, Okhla, New Delhi			Sri City, Chittoor			AR-104		
						STRUCTURAL CONSULTANT			COPYRIGHT					
						Jehovaking Engineering Consultants Pvt. Ltd.			This drawing is the property of Aadharshila Designs Pvt. Ltd. It shall not be copied, used in any manner and handed over to any person or party without the prior permission of Aadharshila Designs Pvt. Ltd.					
						6th Cross Street, Lakshmi Nagar, Ponur, Chennai - 600116			Andhra Pradesh					

 

R2

SCHEDULE OF FINISHES - MULTIPURPOSE SPORTS BLOCK				
Sl.	Space	Floor	Wall	Ceiling
A Internal Finishes				
1	Main Entrance Lobby, Rear Entrance Lobby, Passages	Polished Kota with combination of colours	Acrylic Emulsion Paint	Combination of moisture Resistant Gypsum Board & Mineral Fibre Tile False Ceiling
2	Lift Lobby		Polished Granite Cladding (Facia Only) till ceiling	
3	Staircases & Internal Ramp	Leather Finish Single Piece Granite at Treads, Polished Granite at Risers	Acrylic Emulsion Paint	Acrylic Emulsion Paint
4	External Ramps and Steps	Leather Finish Granite Flooring		
5	Stage Area & Pre-stage Area	Wooden Flooring	Combination of Gypsum Board & Acoustic Wall Panels	Combination of moisture Resistant Gypsum Board & Acoustic Tile False Ceiling
6	Admin & Trainer Office, Visitor Room, Green Rooms, AV Room, First Aid	Double Charged Vitrified Floor Tiles (800x800mm) with 3mm Epoxy Grout		
7	Lobby with Carrom & Chess (Below 1st Floor Gallery seating)			
8	Gym (Functional Training & Strength Training)	Sports grade Vinyl Flooring with Combination of Colours	Soft board with Fabric Panelling upto 2100mm + Mirrors at specific locations	Acrylic Emulsion Paint
9	Main Sports Hall (Courts & adjoining Passages)	Concrete flooring with towel finish and playing courts shall be marked in enamel paint	Soft board with Fabric Panelling upto 2100mm, Acrylic Emulsion Paint till Masonry Wall height, Rest Fireproof Paint in MS members	Standing Seam with insulation / PUF Panel Roofing, Fireproof Paint in all Truss & Steel members
10	Table Tennis Courts		Soft board with Fabric Panelling upto 2100mm, rest as Acrylic Emulsion Paint till ceiling	Acrylic Emulsion Paint
11	First Floor Gallery Seating	Kota / Granite / Tile Flooring	Soft board with Fabric Panelling upto 2100mm	Standing Seam with insulation / PUF Panel Roofing, Fireproof Paint in all Truss & Steel members
12	Common & PH Toilets, Lockers, Drinking Water Kiosks, Pantry	Matt Finish Rectified Ceramic Floor Tiles (600x600mm) with 3mm Epoxy Grout	Rectified Ceramic Wall Tiles (300x600mm) with 3mm Epoxy Grout + top Granite band, rest Acrylic Emulsion Paint upto ceiling	Combination of Moisture Resistant & Calcium Silicate Tile & Gypsum board False Ceiling
13	Electrical Room & Store	Kota Stone Flooring	Acrylic Emulsion Paint	
14	UG & OH Water Tanks	Glazed Ceramic Floor Tiles (300x300mm)	Glazed Ceramic Floor Tiles (300x300mm) upto full height	Acrylic Emulsion Paint
15	Open RCC Terraces	Heat Reflective Tiles	Exterior grade Acrylic Emulsion Paint at Parapet	
B General Items				
1	System Aluminum glazing at all Glazings and Windows. MS Rolling shutter with vision panel. MS Fire Doors with Vision panels.			
2	All ventilators & Toilet louvers in Aluminum.			
3	All Internal door frames shall be Factory fabricated Second Class Teak wood with 35mm thk. commercial prelaminated flush door shutters.			
4	Laminated flush door with wooden frame at all Toilets Drinking Water kiosks, lined with 1mm thk. PVC sheet on internal side. PH Door with 1mm thk. SS kick plate. (Optional WPC Doors)			
5	MS works wherever applicable as per design will be Galvanised / Epoxy coated. Aluminium works will be Powder Coated. SS 304 grade Brushed finish Steel in all staircases & railings.			
6	Ground Floor including Halls shall have Grade Slab with Vacuum Dewatered Flooring as base, which is essential for Sports areas.			
7	Floor margin considered as 100mm at all levels. Skirting of 100mm shall be of same material as flooring unless otherwise specified. In case of Vinyl / Wooden Floors, Aluminum skirting to be used.			
8	Floor mounted single piece WCs at all toilets. No Indian WCs. All Urinals with Push type flush. Counter-top Wash Basins as per location. PH Toilets with Pedestal Wash Basins.			
9	Polished Black Granite at all Wash Basin counters, Pantry counter and window cills. Tactile tiles at Lobbys & Passages of Ground & First Floors.			
10	All junctions of different flooring shall have a Polished Black Granite Threshold. Lift car will have polished Granite Flooring.			
11	All Toilets and Drinking Water areas will have 150mm structural sunk slab with light-weight filling. Pipes to be core-cut in the slab & run between the False Ceiling & Slab soffit.			
12	Ground Floor Gallery Seating platforms & steps in civil work. HDPE Bleachers without legs for seating.			
13	First Floor Gallery Seating will have Lightweight Concrete Filling. Foldable HDPE seats with legs.			
C External Finishes				
1	Combination of Natural Mineral based Texture Paint and Exterior grade Acrylic Emulsion paint with shade patterns and Grooves as per design & location.			
2	High performance SGU at all external windows & openings, with combination of Spandrel Glazing above lintels. MS Grills inside.			
3	Terracing with waterproofing and Heat Reflective Tiles combined as per approved specification.			
4	Shafts covered with CNC cut design in weather resistant WPC panels supported by MS/ Aluminum Frames. Openable panels / doors at ground level for shaft access.			
5	All shafts shall be plastered & painted inside with water-proof cement paint. MS rungs & Grill platforms at each floor to access all heights.			
6	Lift shall be Machine Room less.			
D Note: Shop Drawings to be provided by the Contractor for:				
1	All MS and Aluminum works, WPC Cladding & Fixing Details, All Glazing Details			
Execution shall be carried out based on approved Shop Drawings & Site Mock-up.				

NOTES:

1. All dimensions are in mm unless noted otherwise.

2. The dimensions are to be read and not scaled off the drawing.

3. Any discrepancy in the drawing shall be brought to the notice of the Architects.

4. This drawing is to be read in conjunction with other relevant drawings & specifications given in the tender document.

5. Only the latest revision of the drawings shall be considered valid for all purposes.

REVISIONS:

SL.	DATE	DESCRIPTION
R1	24.09.2025	Updated as marked & instructed by IIITS on 22.07.2025
-	-	-
-	-	-
-	-	-
-	-	-
-	-	-
-	-	-
-	-	-

ELECTRICAL CONSULTANT

SV Intense Engineering Infrastructure Pvt. Ltd.

Velachery, Chennai - 600042

PLUMBING & FIRE-FIGHTING CONSULTANT

Behera & Associates

F-623A, Lado Sarai, Behind CNG Station, New Delhi

HVAC CONSULTANT

Abid Husain Consultants

LG-1&2, Jeevan Prakash Apartment, 16A, Okhla, New Delhi

STRUCTURAL CONSULTANT

Jehovaking Engineering Consultants Pvt. Ltd.

6th Cross Street, Lakshmi Nagar, Porur, Chennai - 600116

PROJECT

Infrastructure Development at IIIT Sri City Chittoor

CLIENT

Indian Institute of Information Technology

Sri City, Chittoor

Andhra Pradesh

ARCHITECT

ADPL

Aadharshila Designs Pvt. Ltd.

B - 4/124, L. G. F., Safdarjung Enclave, New Delhi - 110029.

Tel : +91 11 26100433 - 6, Fax : +91 11 26177678,

E-mail : adpl@adpl.in

COPYRIGHT

This drawing is the property of Aadharshila Designs Pvt. Ltd. It shall not be copied, used in any manner and handed over to any person or party without the prior permission of Aadharshila Designs Pvt. Ltd.

DRAWING TITLE

Schedule of Finishes

Multipurpose Sports Block

N

DATE

25.06.2025

SCALE

NTS @ A3

REV.


DRAWING NO.

IIITS / MSB / TD / AR-111


R1

DETAILED ARCHITECTURAL DRAWINGS (TENDER STAGE)


DETAILED ARCHITECTURAL DRAWINGS (TENDER STAGE)

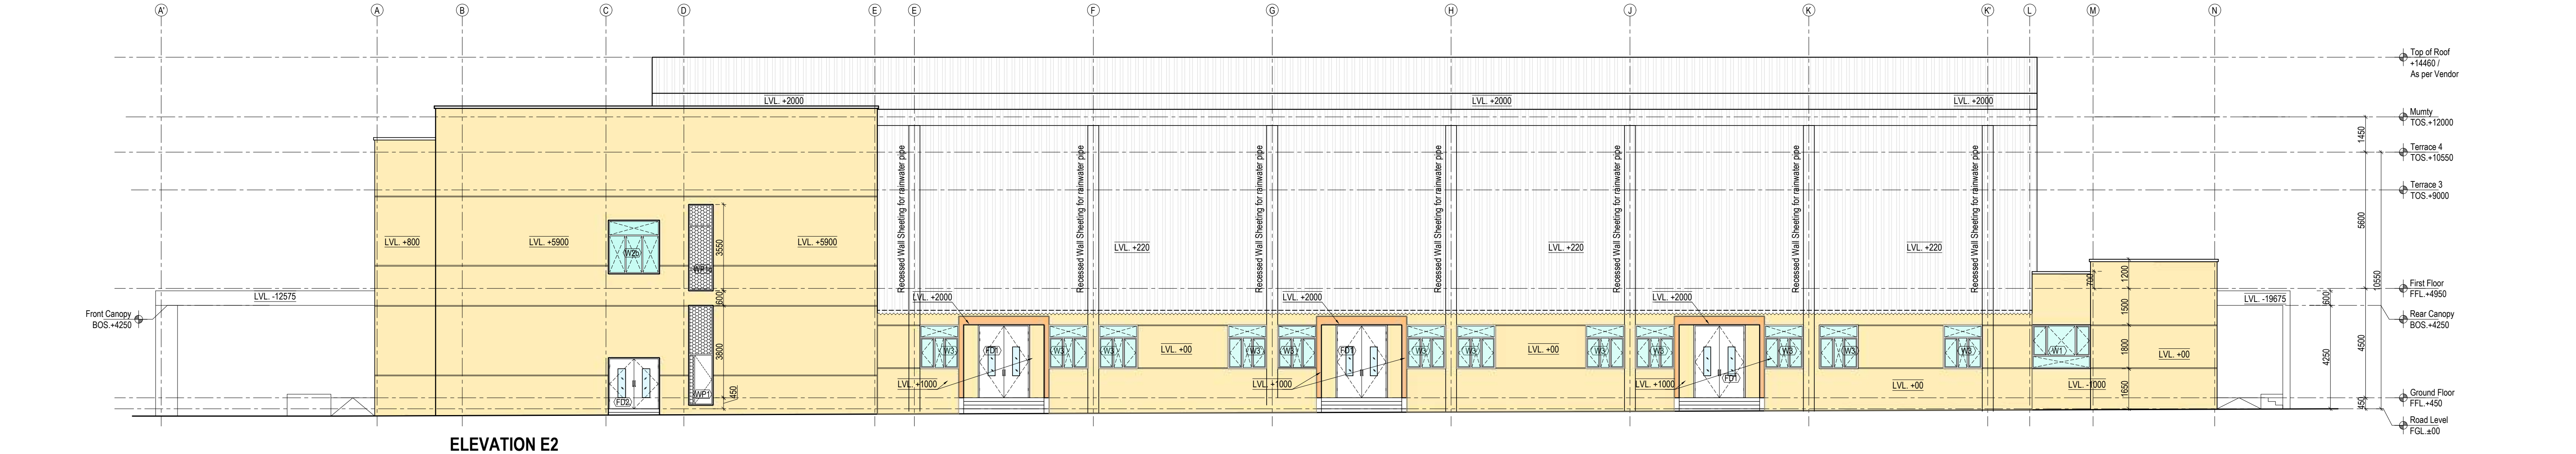


NOTES: 1. All dimensions are in mm unless noted otherwise. 2. The dimensions are to be read and not scaled off the drawing. 3. Any discrepancy in the drawing shall be brought to the notice of the Architects. 4. This drawing is to be read in conjunction with other relevant drawings & specifications given in the tender document. 5. Only the latest revision of the drawings shall be considered valid for all purposes.	REVISIONS:		ELECTRICAL CONSULTANT SV Intense Engineering Infrastructure Pvt. Ltd. Velachery, Chennai - 600042 PLUMBING & FIRE-FIGHTING CONSULTANT Behera & Associates F-623A, Lado Sarai, Behind CNG Station, New Delhi HVAC CONSULTANT Abid Husain Consultants LG-1&2, Jeevan Prakash Apartment, 16A, Okhla, New Delhi STRUCTURAL CONSULTANT Jehovaking Engineering Consultants Pvt. Ltd. 6th Cross Street, Lakshmi Nagar, Porur, Chennai - 600116	PROJECT Infrastructure Development at IIIT Sri City Chittoor CLIENT Indian Institute of Information Technology Sri City, Chittoor Andhra Pradesh	ARCHITECT  Aadharshila Designs Pvt. Ltd. B - 4/124, L. G. F., Saldarjung Enclave, New Delhi - 110029 Tel. +91 11 26100433 - 6, Fax : +91 11 26177678, E-mail : adpl@adpl.in COPYRIGHT This drawing is the property of Aadharshila Designs Pvt. Ltd. It shall not be copied, used in any manner and handed over to any person or party without the prior permission of Aadharshila Designs Pvt. Ltd.	DRAWING TITLE		REV.	
	SL	DATE				DESCRIPTION	Elevations		
	R1	25.06.2025				Revised as mentioned in drawings			
	R2	24.09.2025				Revised as mentioned in drawings including modifications in Plans	Multipurpose Sports Block		
	-	-				-	DATE		SCALE
	-	-				-	02.06.2025		1:125 @ A1
	-	-				-			
	-	-				-			
	-	-				-			
	-	-				-			
DRAWING NO.		AR-201							
IIITS / MSB / TD /									

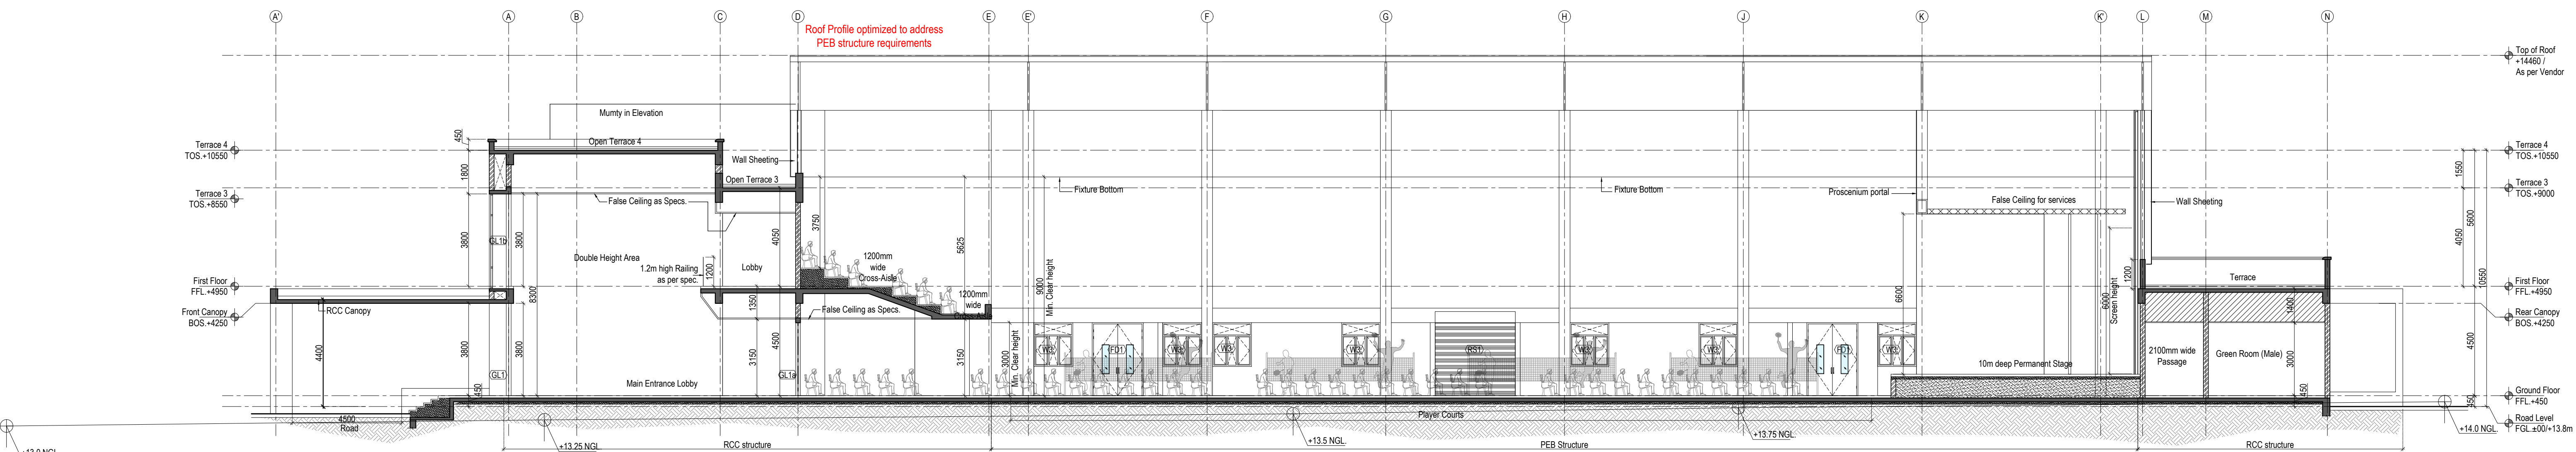


SECTION A

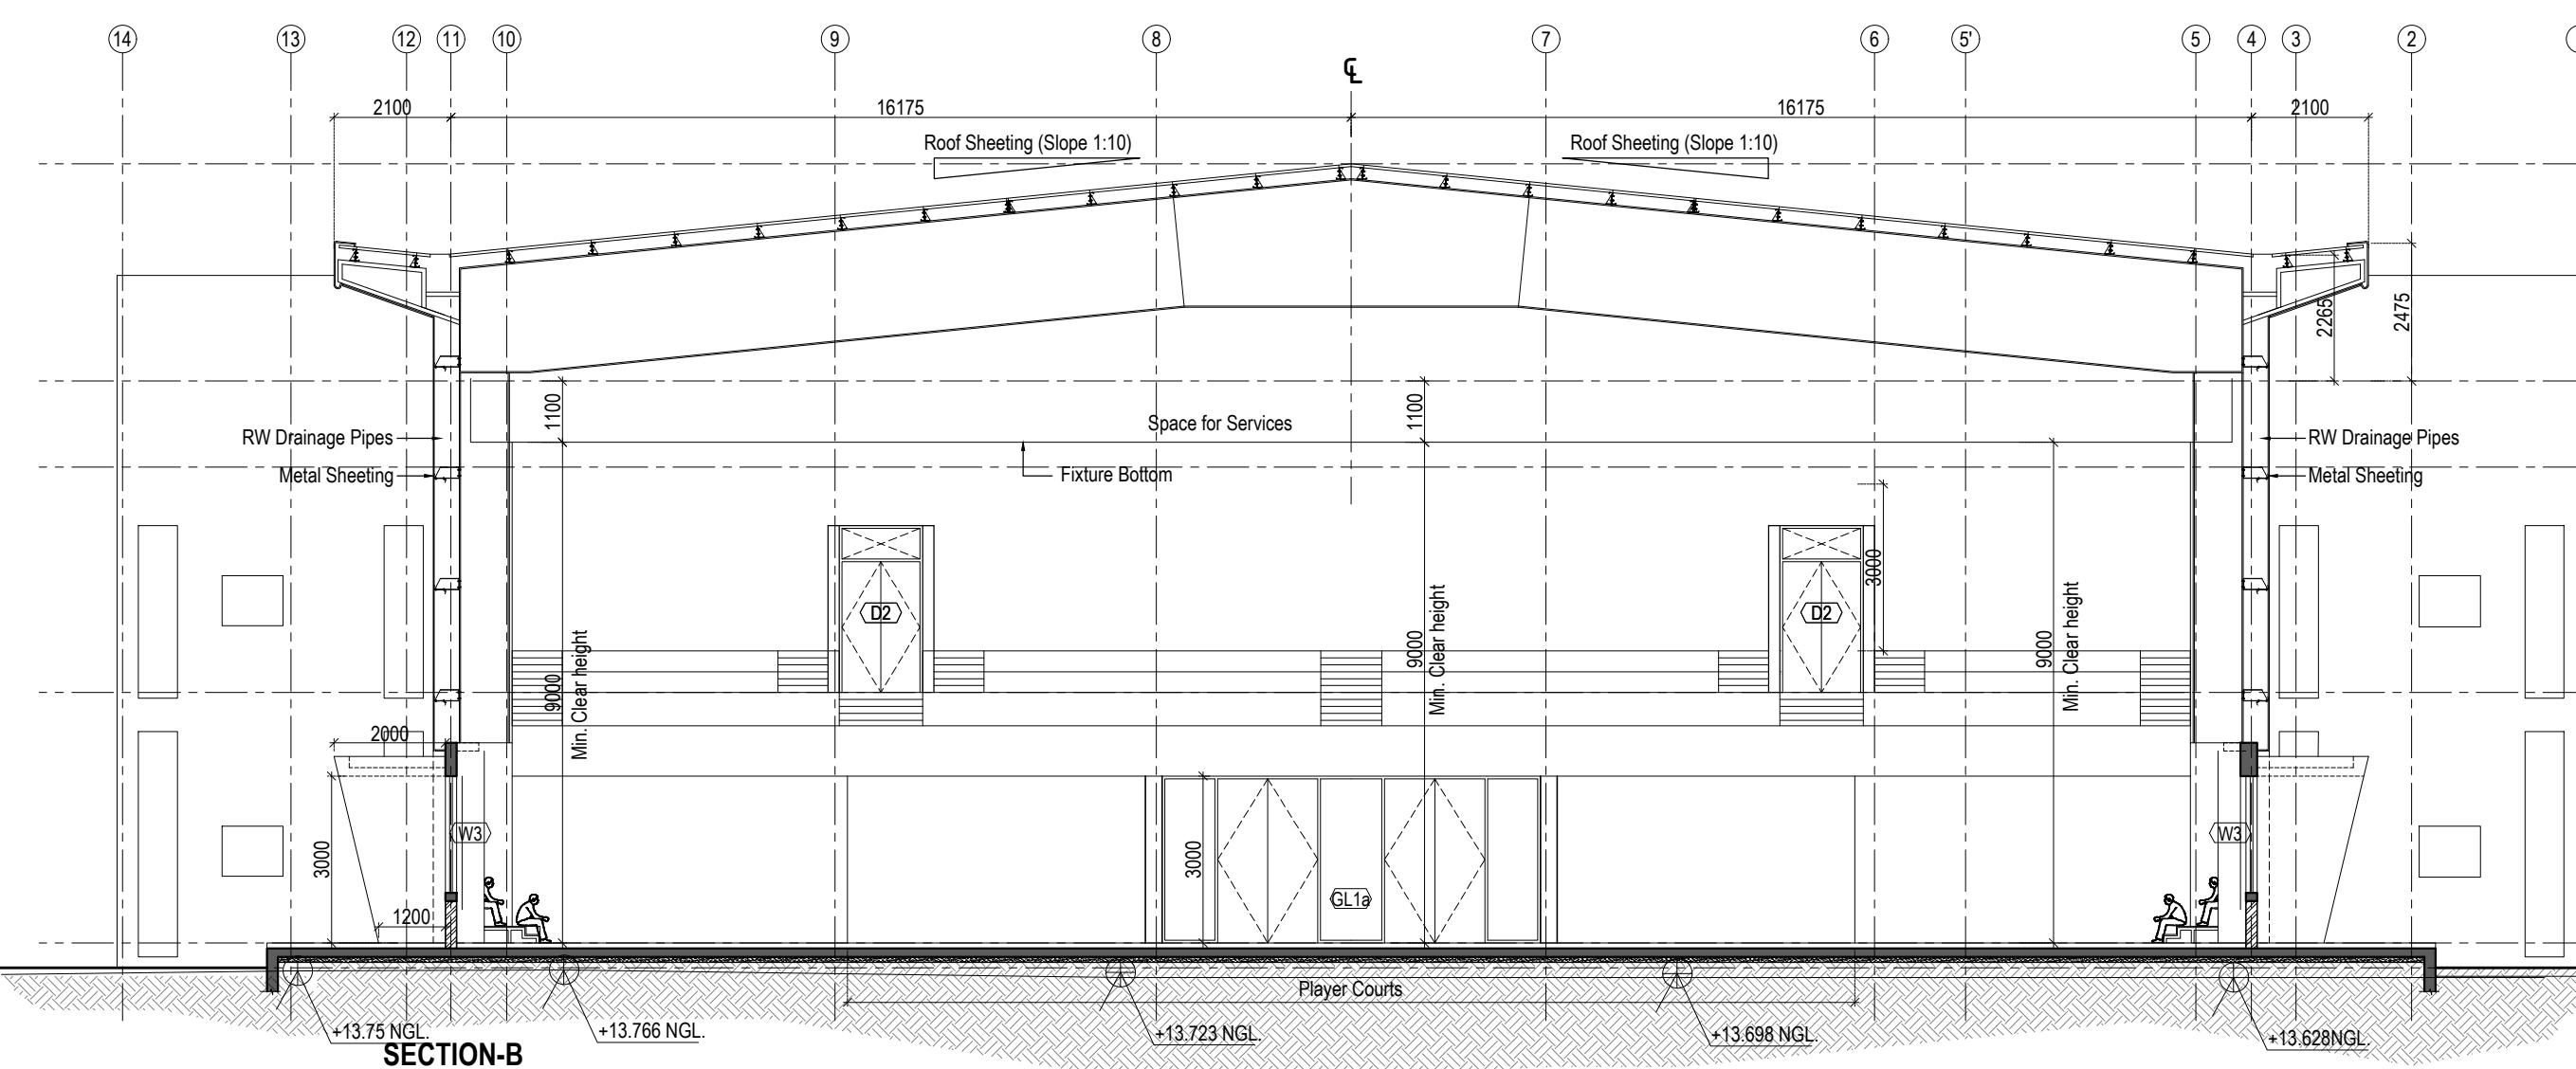


SECTION-B

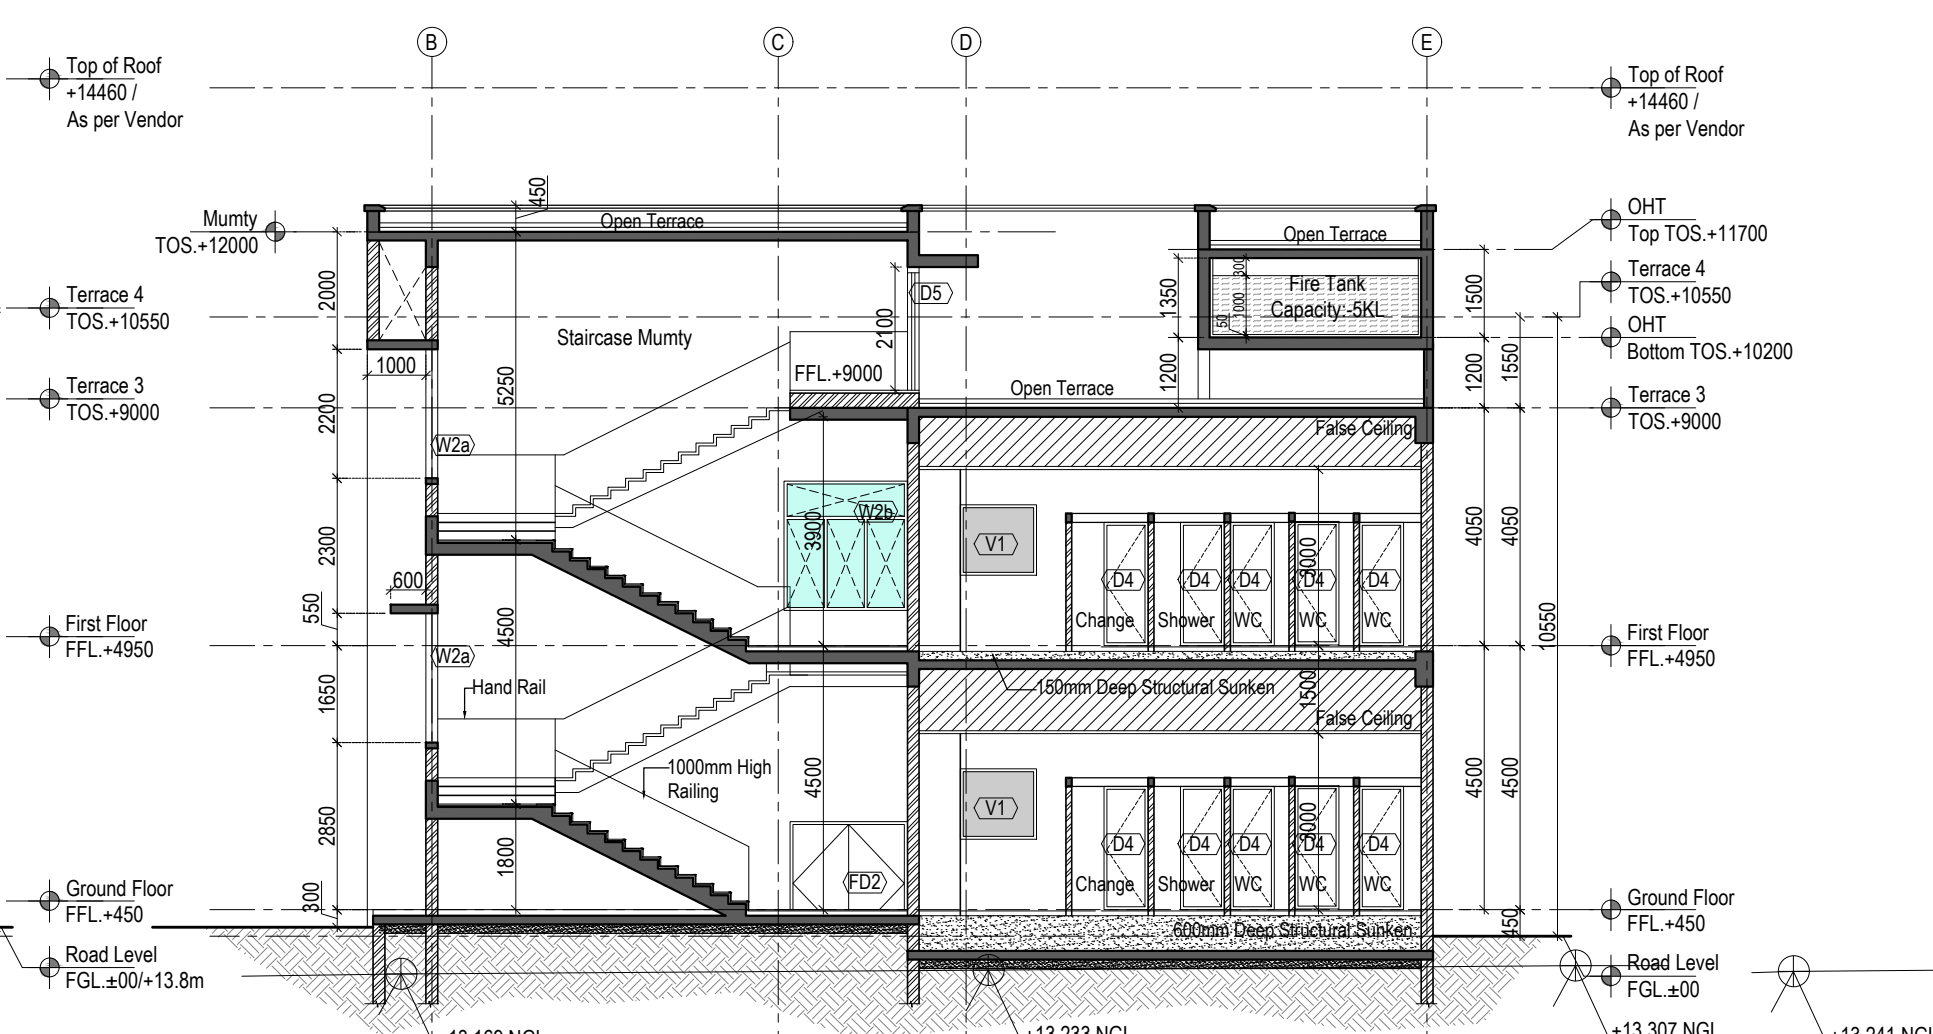


SECTION D

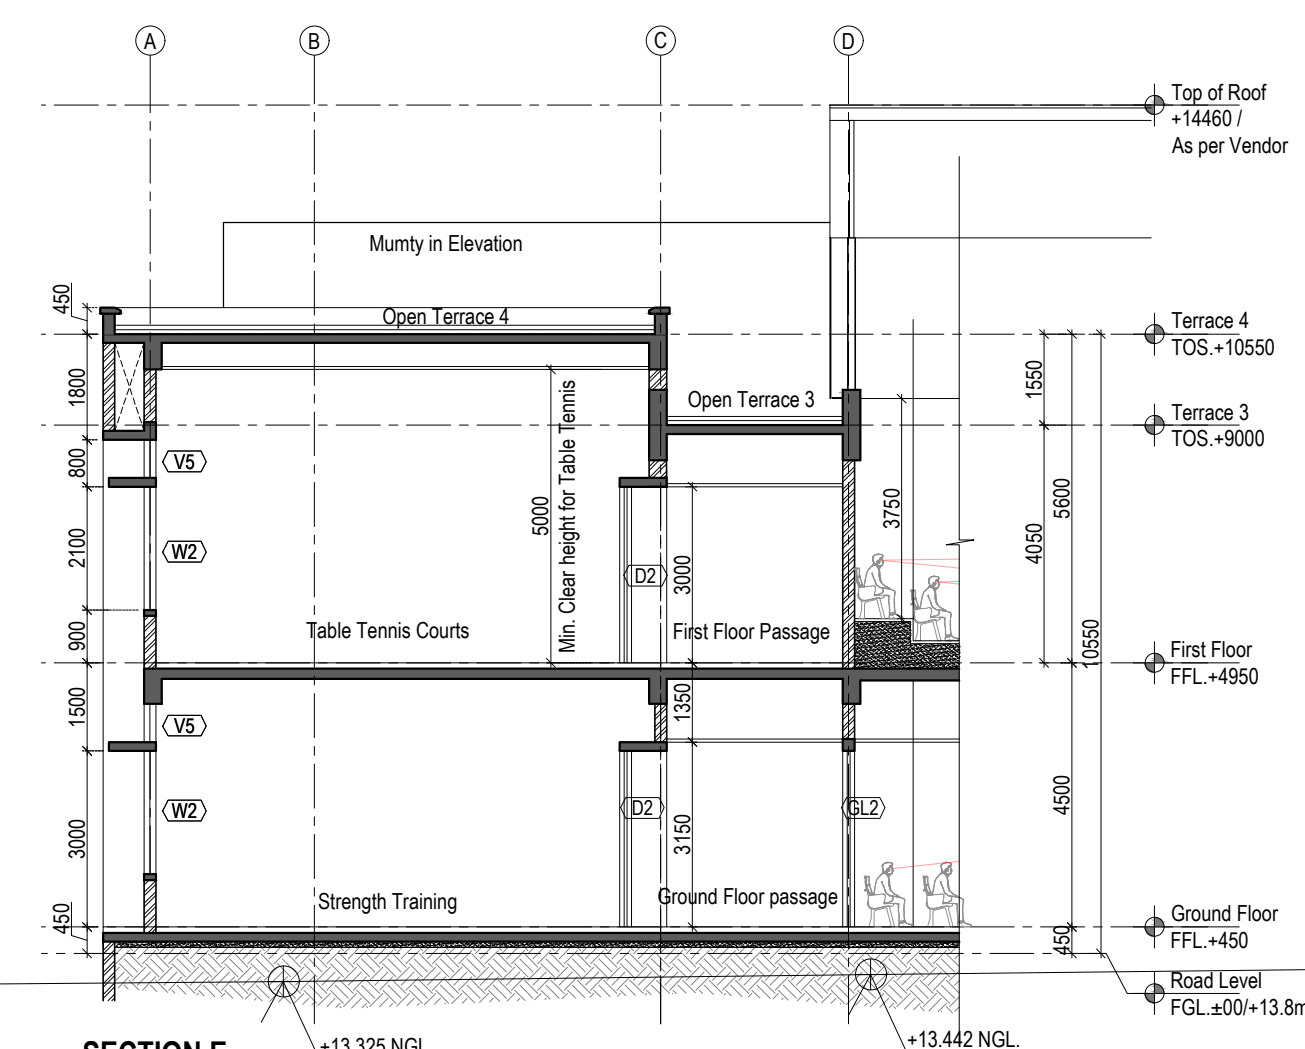

SECTION E

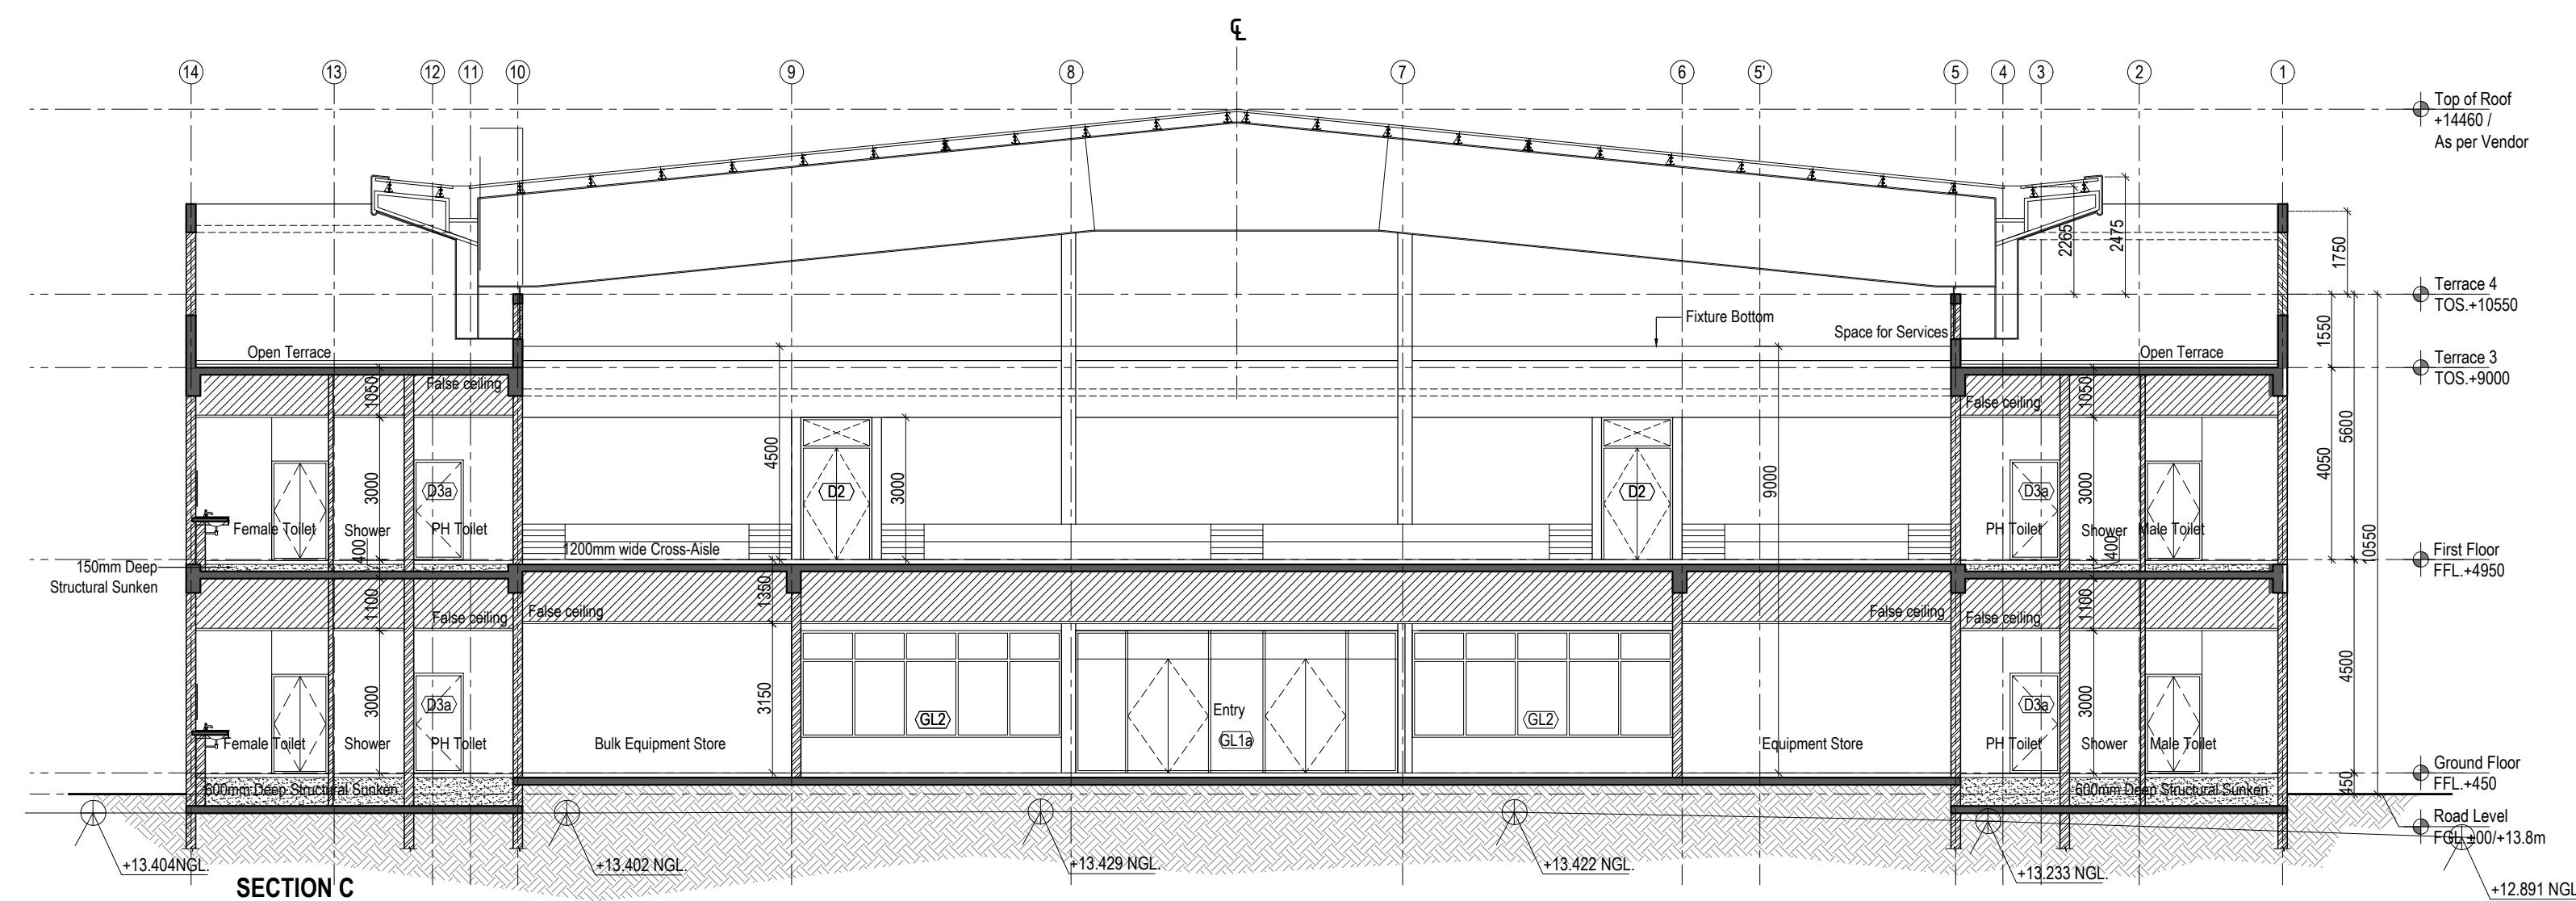

SECTION C

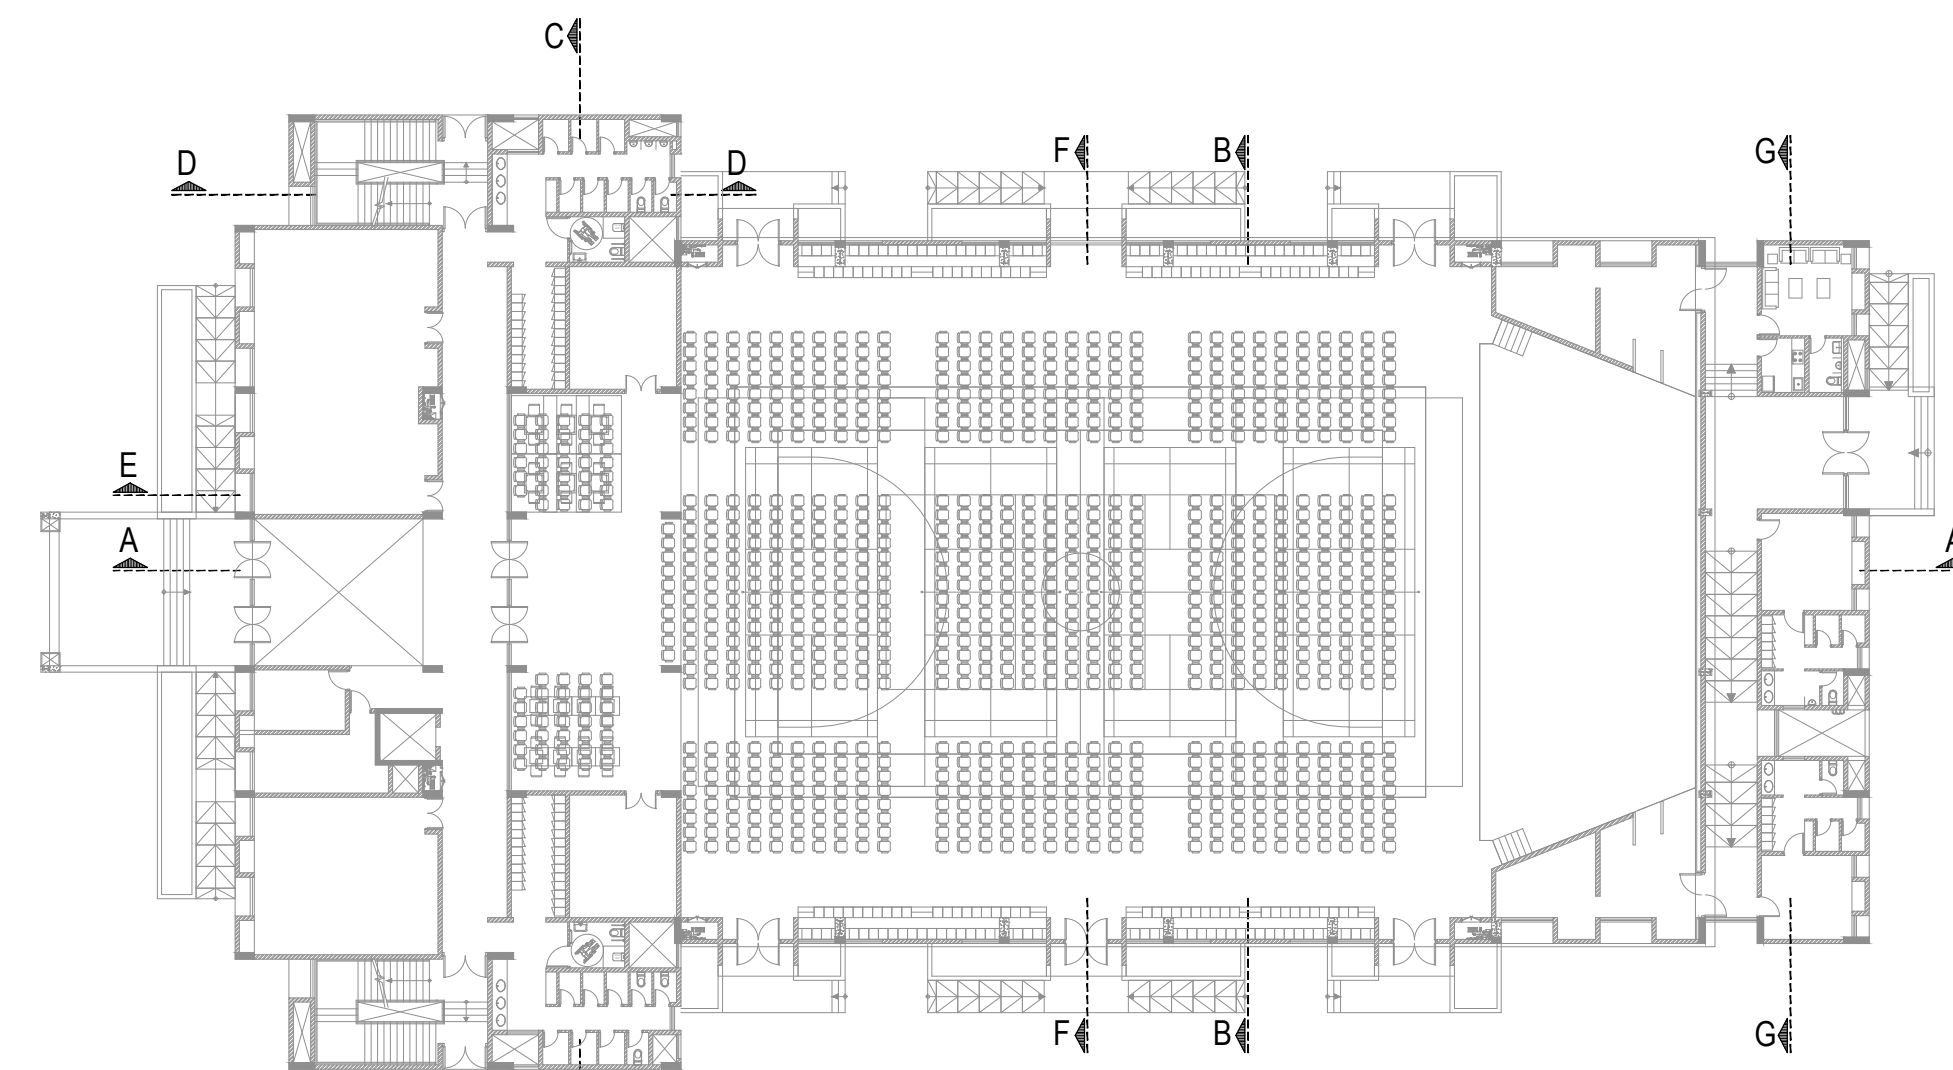

Key Plan
Not to scale

NOTES:	REVISIONS:		
	SL.	DATE	DESCRIPTION
1. All dimensions are in mm unless noted otherwise.	R1	25.06.2025	Revised as mentioned in drawings
2. The dimensions are to be read and not scaled off the drawing	R2	24.09.2025	Revised as mentioned in drawings including modifications in Plans
3. Any discrepancy in the drawing shall be brought to the notice of the Architects.	-	-	-
4. This drawing is to be read in conjunction with other relevant drawings & specifications given in the tender document.	-	-	-
5. Only the latest revision of the drawings shall be considered valid for all purposes.	-	-	-
	-	-	-
	-	-	-
	-	-	-
	-	-	-

ELECTRICAL CONSULTANT SV Intense Engineering Infrastructure Pvt. Ltd. Velncheri, Chennai - 600042
PLUMBING & FIRE-FIGHTING CONSULTANT Behera & Associates F-623A, Lado Sarai, Behind CNG Station, New Delhi
HVAC CONSULTANT Abid Husain Consultants LG-1&2, Jeevan Prakash Apartment, 16A, Okhla, New Delhi
STRUCTURAL CONSULTANT Jehovaking Engineering Consultants Pvt. Ltd. 6th Cross Street, Lakshmi Nagar, Porur, Chennai - 600116

PROJECT	Infrastructure Development at IIIT Sri City Chittoor
CLIENT	Indian Institute of Information Technology Sri City, Chittoor
	Andhra Pradesh

ARCHITECT

AADPL



Aadharshila Designs Pvt. Ltd.

B - 4/124, L. G. F., Safdarjung Enclave, New Delhi - 110029.
Tel. : +91 11 26100433 - 6, Fax : +91 11 26177678,
E-mail : adpl@adpl.in

COPYRIGHT

This drawing is the property of Aadharshila Designs Pvt. Ltd. It shall not be copied, used in any manner and handed over to any person or party without the prior permission of Aadharshila Designs Pvt. Ltd.

DETAILED ARCHITECTURAL DRAWINGS (FOR TENDER)			
not be without	DRAWING TITLE Sections (Sheet 01) Multipurpose Sports Block		REV. R2
	DATE 13.06.2025	SCALE 1:125 @ A1	
	DRAWING NO. IIITS / MSB / TD / AR-301		

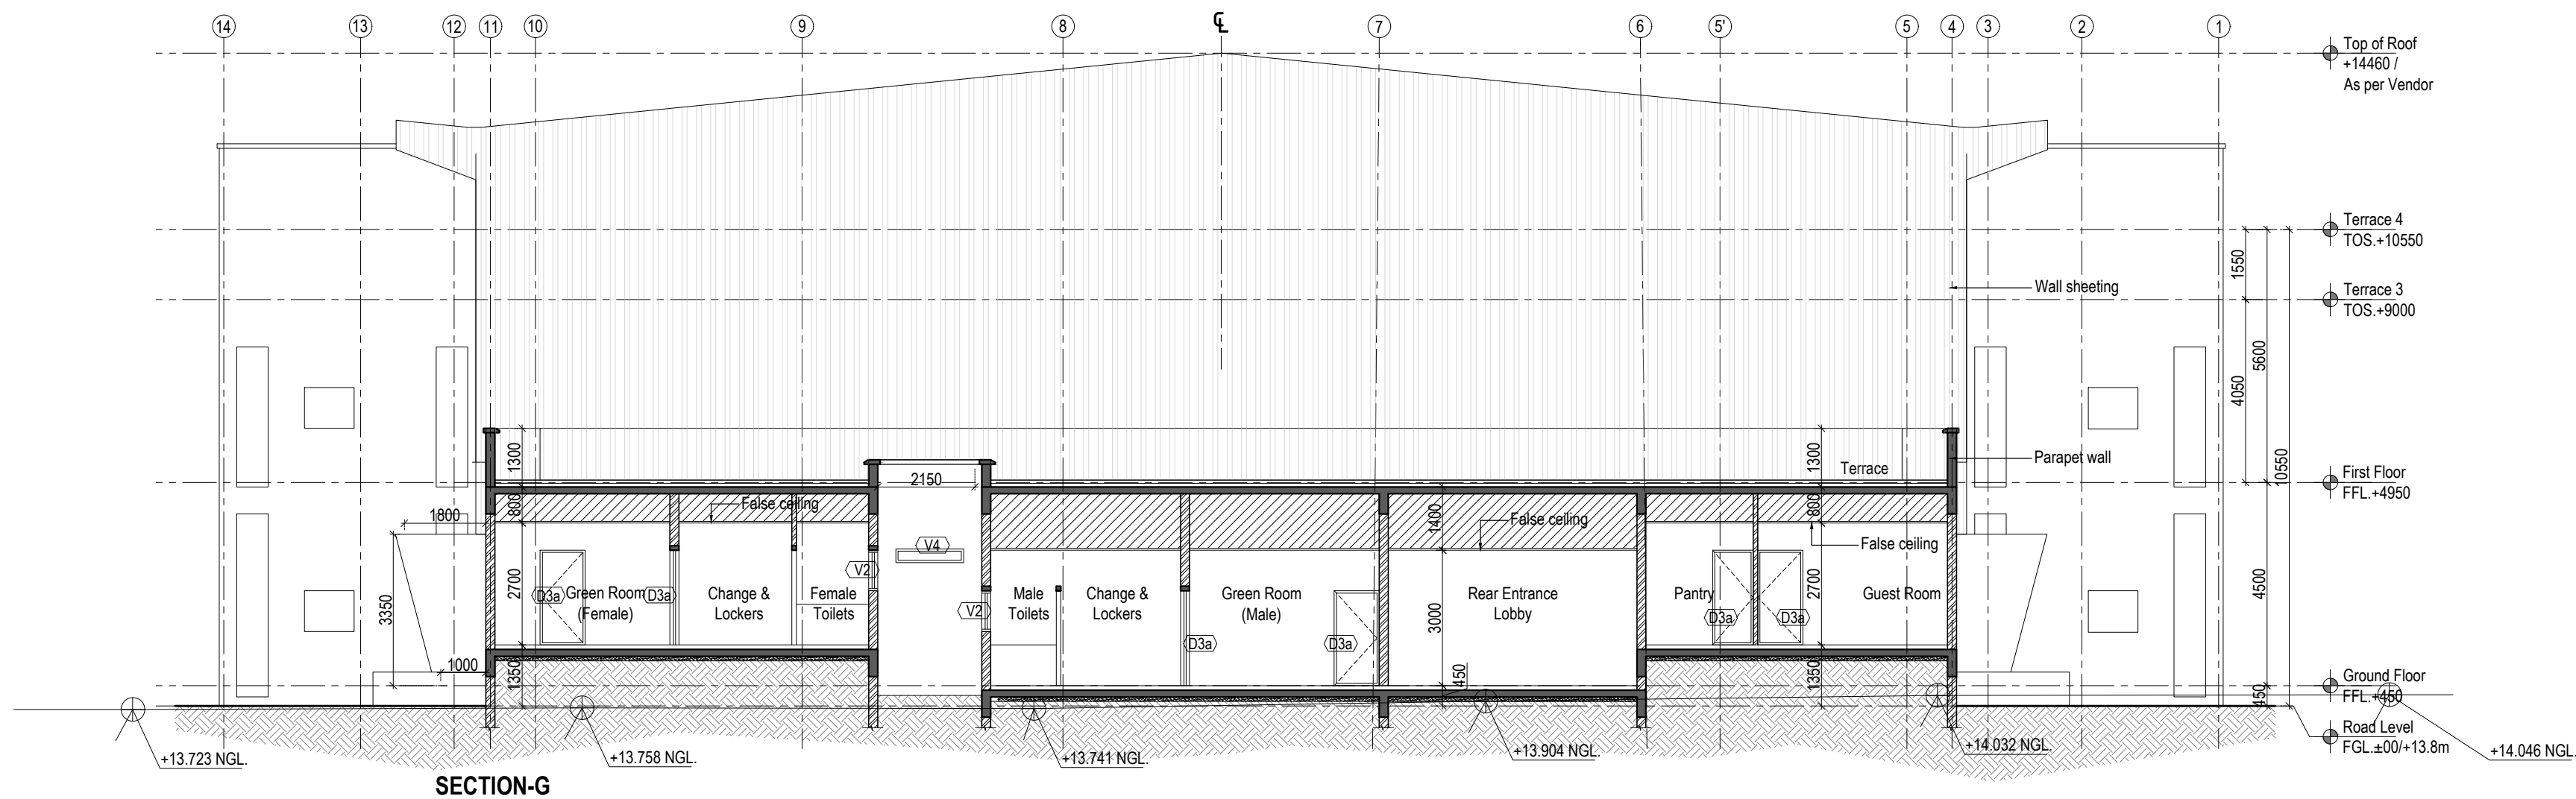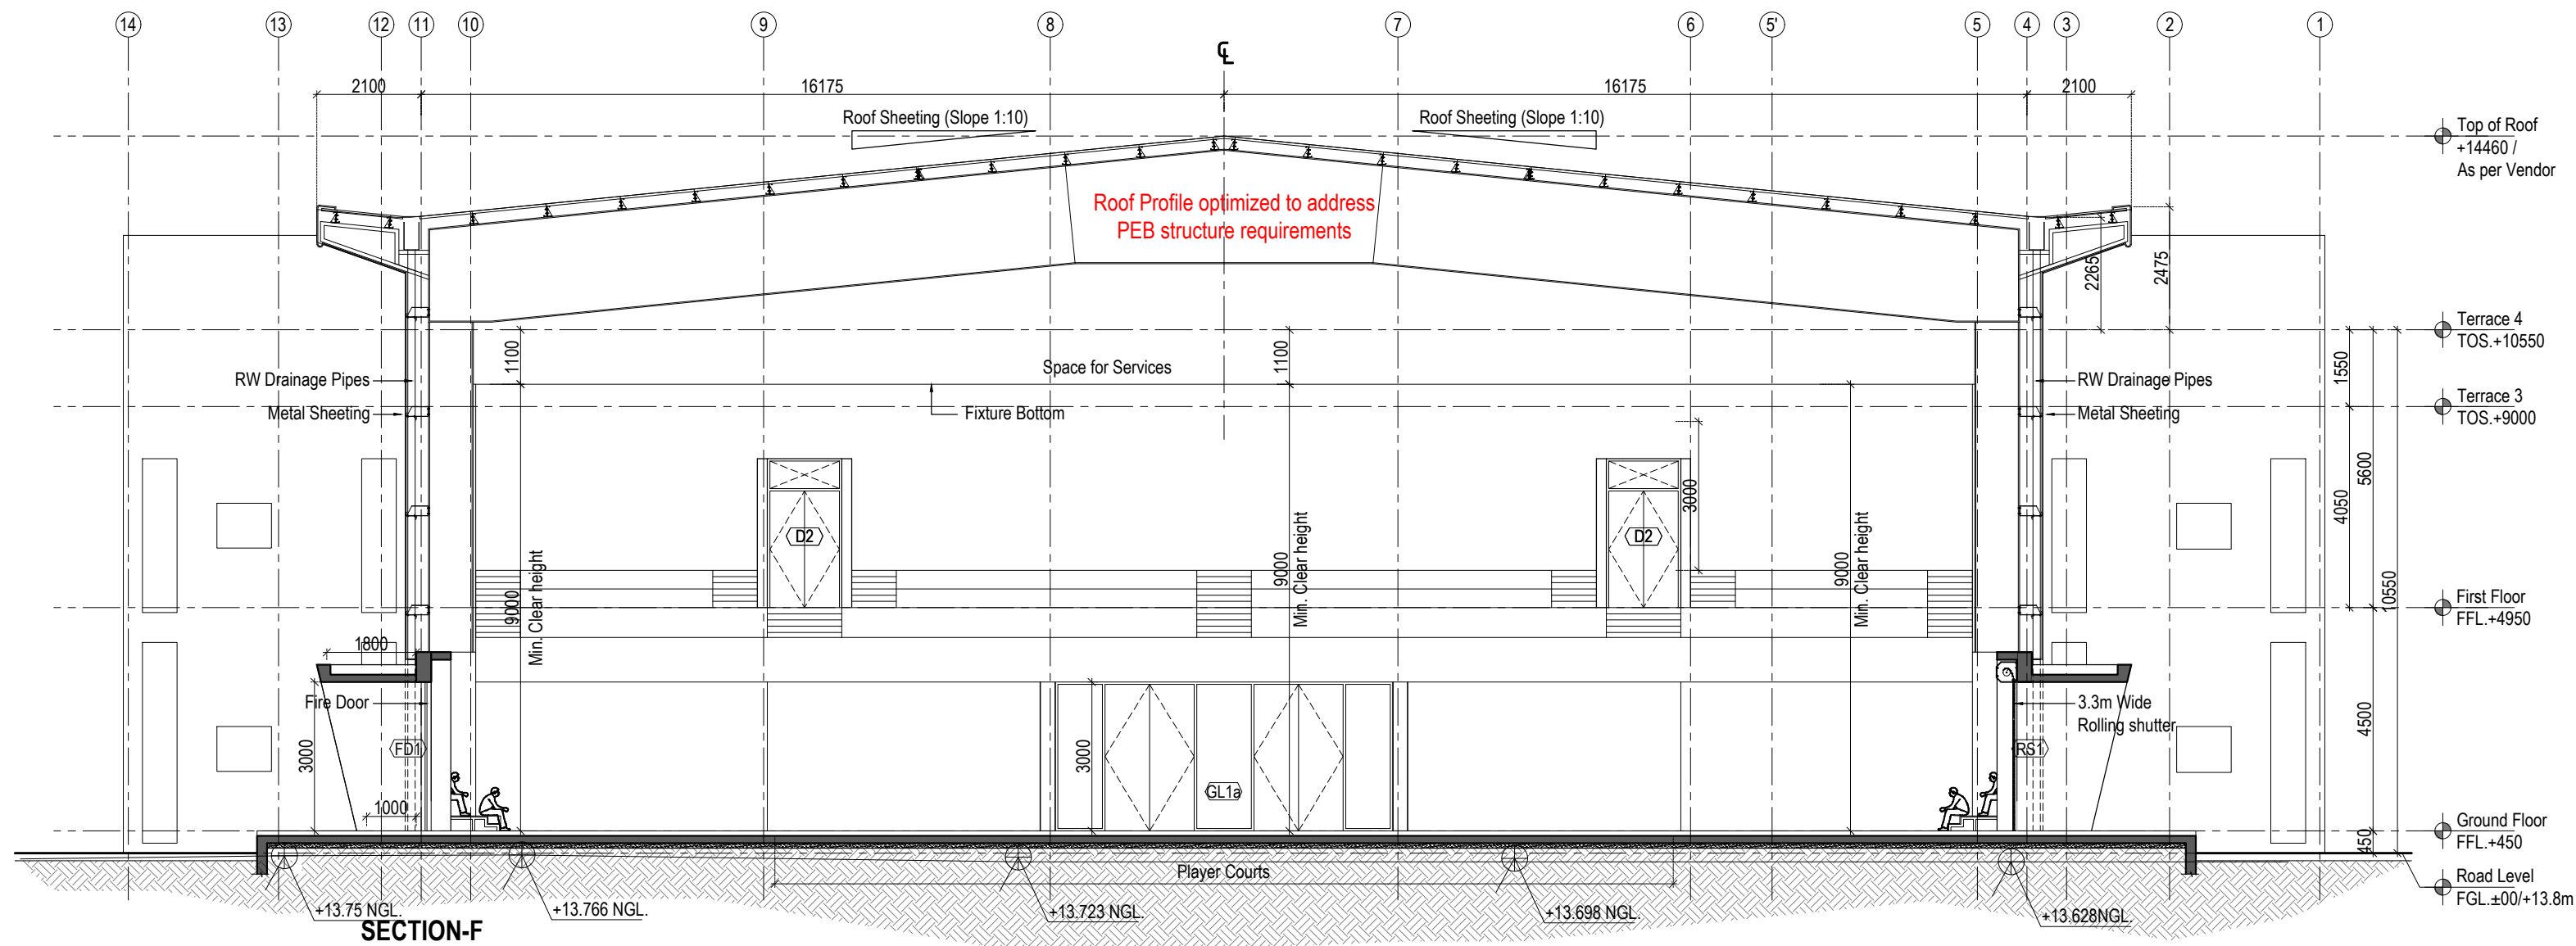

DETAILED ARCHITECTURAL DRAWINGS (FOR TENDER)

NOTES:		REVISIONS:				ELECTRICAL CONSULTANT SV Intense Engineering Infrastructure Pvt. Ltd. Velachery, Chennai - 600042	PROJECT Infrastructure Development at IIIT Sri City Chittoor	ARCHITECT ADPL Aadharshila Designs Pvt. Ltd.	DRAWING TITLE		N REV. R2
1. All dimensions are in mm unless noted otherwise.	2. The dimensions are to be read and not scaled off the drawing. 3. Any discrepancy in the drawing shall be brought to the notice of the Architects. 4. This drawing is to be read in conjunction with other relevant drawings & specifications given in the tender document. 5. Only the latest revision of the drawings shall be considered valid for all purposes.	SL.	DATE	DESCRIPTION					Sections (Sheet 02)		
		R1	25.06.2025	Revised as mentioned in drawings		Multipurpose Sports Block					
		R2	24.09.2025	Revised as mentioned in drawings including modifications in Plans		DATE	SCALE				
		-	-	-		13.06.2025	1:125 @ A2				
		-	-	-							
		-	-	-							
		-	-	-			CLIENT Indian Institute of Information Technology Sri City, Chittoor Andhra Pradesh	B - 4/124, L. G. F., Safdarjung Enclave, New Delhi - 110029. Tel : +91 11 26100433 - 6, Fax : +91 11 26177678, E-mail : adpl@adpl.in	DRAWING NO.		
		-	-	-	STRUCTURAL CONSULTANT Jehovaking Engineering Consultants Pvt. Ltd. 6th Cross Street, Lakshmi Nagar, Porur, Chennai - 600116		COPYRIGHT This drawing is the property of Aadharshila Designs Pvt. Ltd. It shall not be copied, used in any manner and handed over to any person or party without the prior permission of Aadharshila Designs Pvt. Ltd.	IIITS / MSB / TD / AR-302			