


FIRE FIGHTING LEGEND:-	
(A)	100Ø FIRE HYDRANT PIPE
(B)	DRAIN PIPE
⊙	CO2 TYPE 4.5 KG FIRE EXTINGUISHER
⊗	ABC TYPE 6KG FIRE EXTINGUISHER


PLUMBING LEGEND:-	
(1)	110 OD uPVC SWR TYPE-B SOIL PIPE
(2)	110 OD uPVC WR TYPE-B WASTE PIPE
(3)	D.W.S DOWN TAKE PIPE
(4)	D.W.S RISER PIPE TO OHT
(5)	110 OD uPVC RAIN WATER PIPE FOR TERRACE

PLUMBING NOTES:-	
1.	WASH BASIN TO FLOOR TRAP (FT) 40 OD WASTE PIPE
2.	MULTI TRAP TO FLOOR TRAP 50 OD WASTE PIPE
3.	KITCHEN SINK TO FLOOR TRAP (FT) 50 OD WASTE PIPE
4.	110 OD uPVC PIPE TO BE USE FOR SOIL & WASTE LINE.
5.	110 OD uPVC 6 kg/cm2 PIPE USED FOR TERRACE RAIN WATER.
6.	90 Od Upvc 6 kg/cm2 PIPE USED FOR TERRACE RAIN WATER.
FT	⊙ FLOOR TRAP(110X110MM)
FD	⊙ FLOOR DRAIN (110X63MM)
UT	⊙ URINAL TRAP DRAIN (110X110MM)
COP	CLEAN OUT PLUG


PLUMBING LEGEND:-	
GT	GULLY TRAP 300X300mm
SEWER M.H	SEWER MANHOLE SIZE 600X600mm & 750X750mm
CH	STORM WATER CATCH BASIN SIZE 450X500mm & 600X600mm

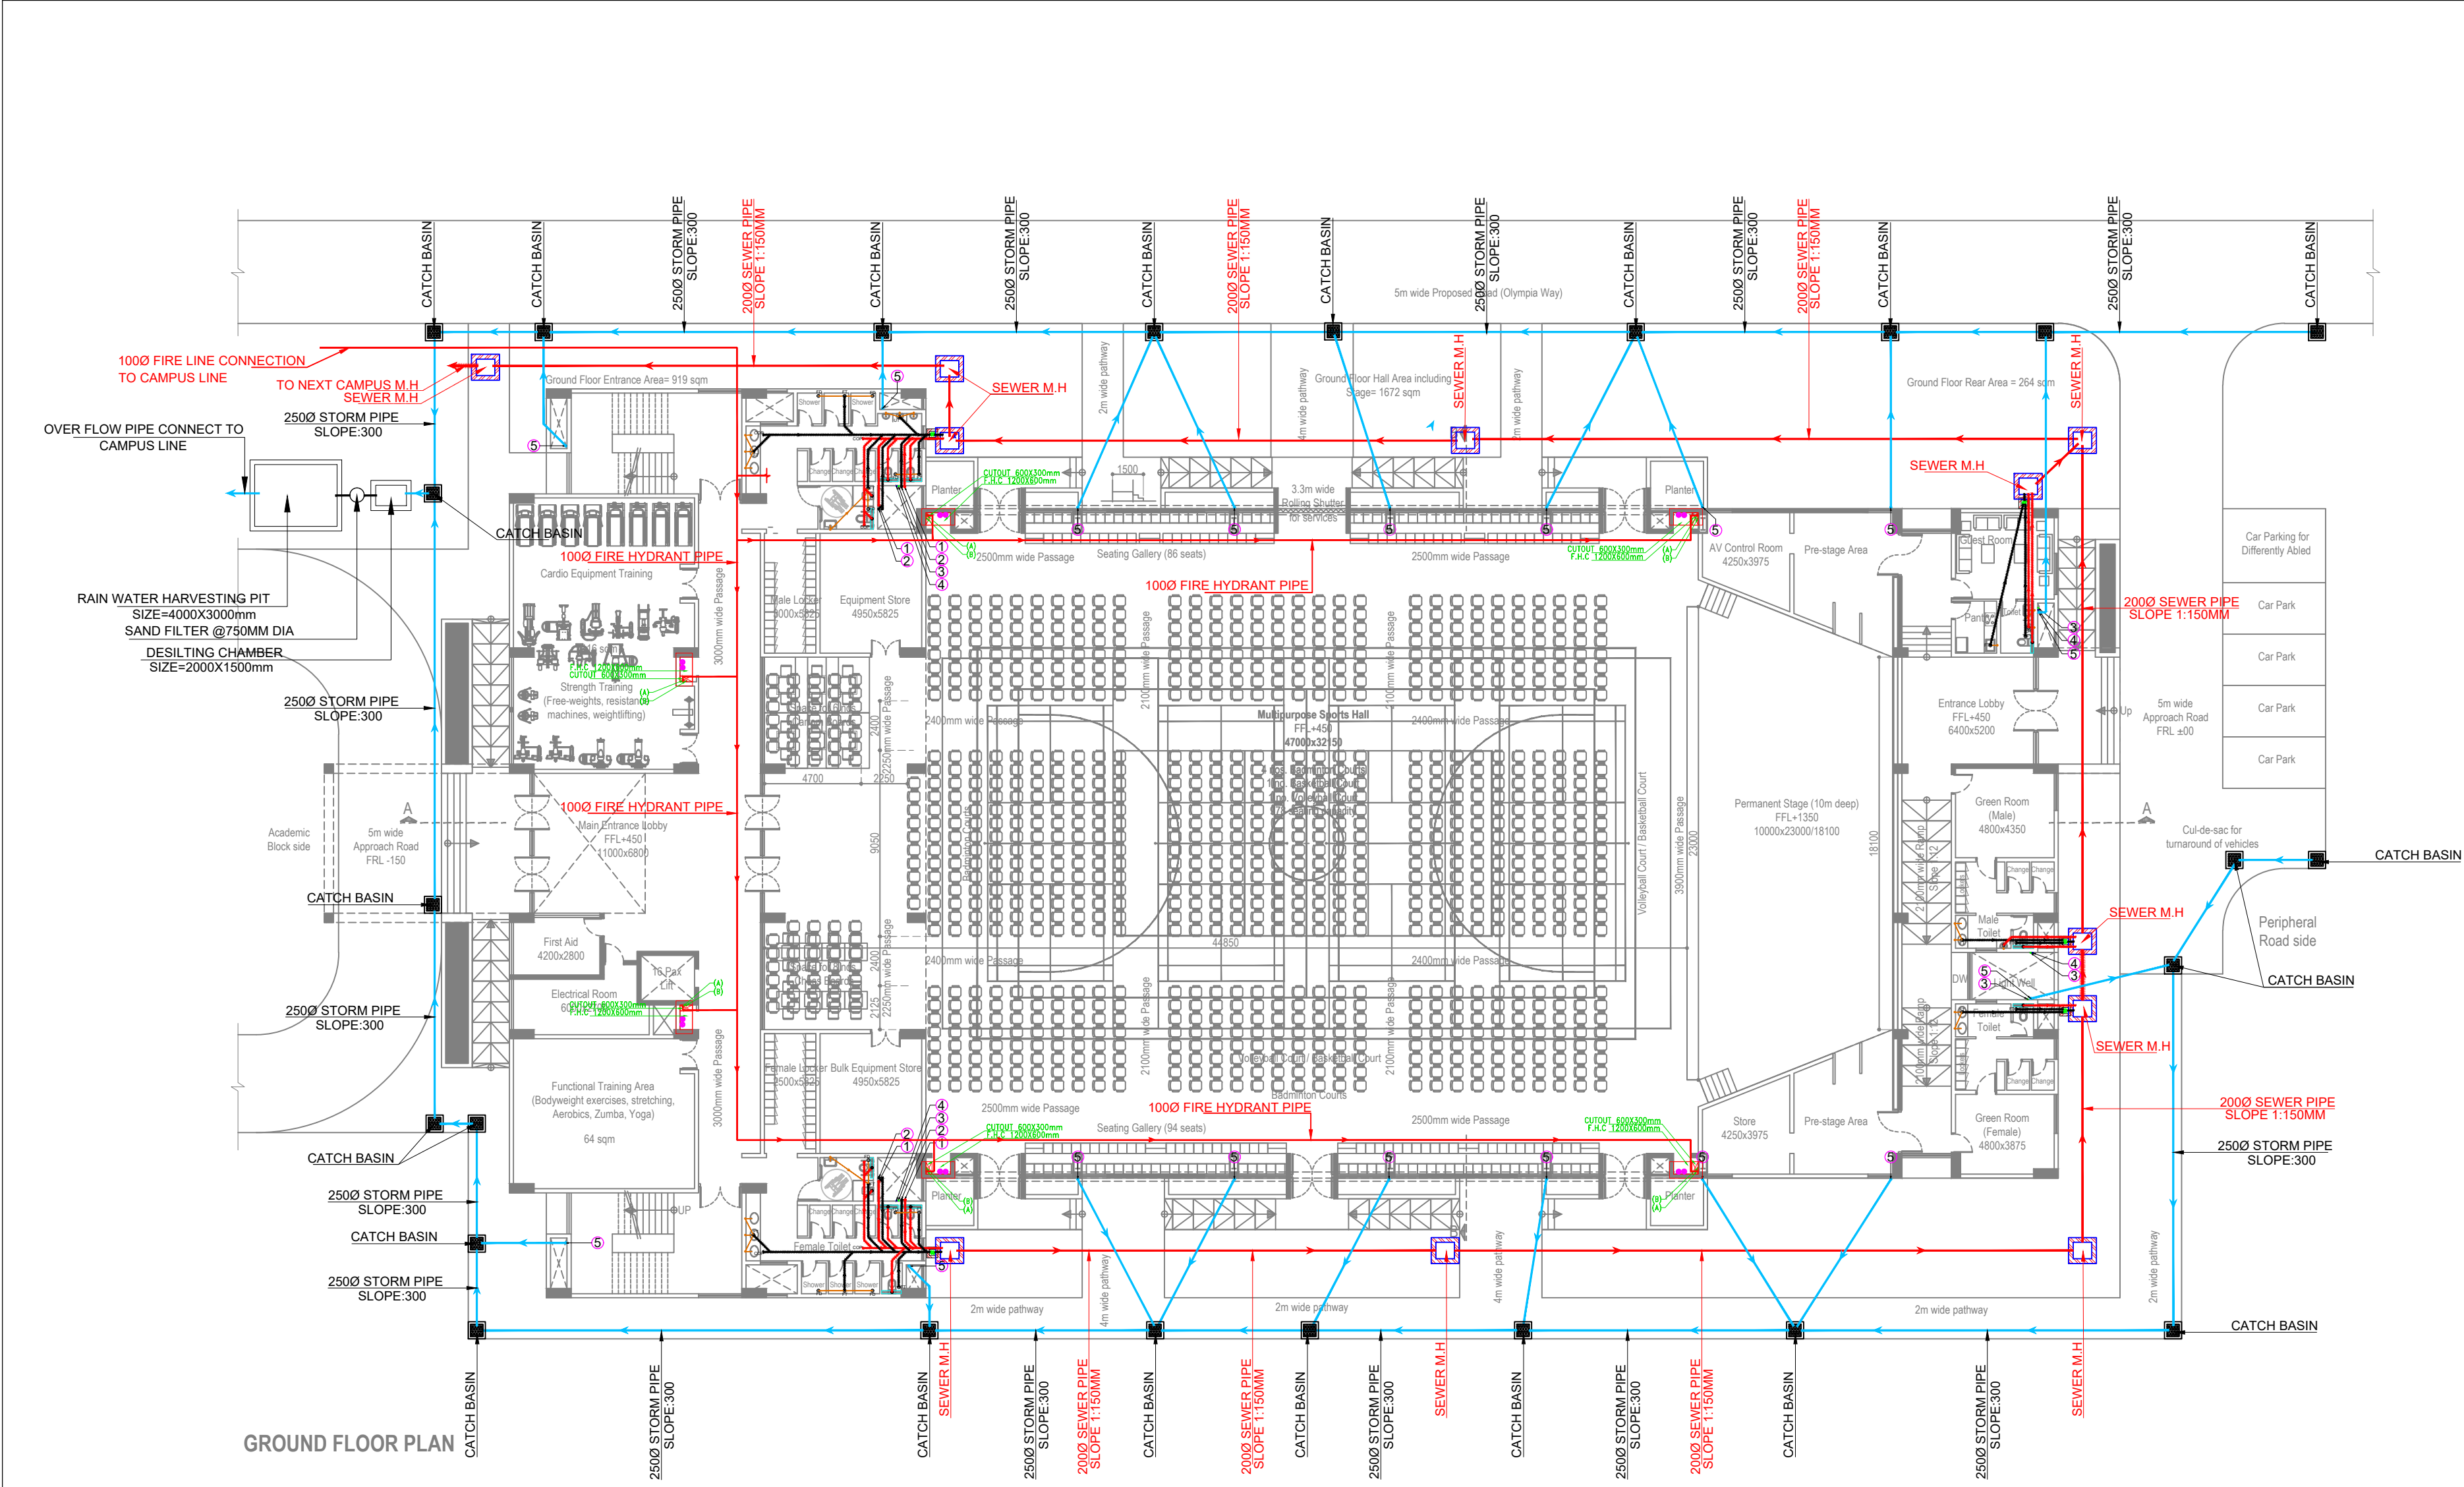

 DETAILED PLUMBING & FIREFIGHTING DRAWINGS (FOR TENDER)

NOTES:	REVISIONS:			ELECTRICAL CONSULTANT SV Intense Engineering Infrastructure Pvt. Ltd. Velachery, Chennai - 600042	PROJECT Infrastructure Development at IIIT Sri City Chittoor	ARCHITECT  Aadharshila Designs Pvt. Ltd.	DRAWING TITLE Drainage & Firefighting Layouts - Ground Floor			
1. All dimensions are in mm unless noted otherwise. 2. The dimensions are to be read and not scaled off the drawing. 3. Any discrepancy in the drawing shall be brought to the notice of the Architects. 4. This drawing is to be read in conjunction with other relevant drawings & specifications given in the tender document. 5. Only the latest revision of the drawings shall be considered valid for all purposes.	SL.	DATE	DESCRIPTION	PLUMBING & FIRE FIGHTING CONSULTANT Behera Associates Pvt Ltd F-623A, Lado Sarai, Behind CNG Station, New Delhi	CLIENT Indian Institute of Information Technology Sri City, Chittoor Andhra Pradesh	B - 4/124, L. G. F., Safdarjung Enclave, New Delhi - 110029.Tel : +91 11 26100433 - 6, Fax : +91 11 26177678, E-mail : adpl@adpl.in	Multipurpose Sports Block		REV. R0	
	-	-	-				DATE 13-06-2025			SCALE NTS @ A2
	-	-	-				DRAWING NO. IITS/MSB/TD/PLFF-101			
	-	-	-							
	-	-	-							
	-	-	-							
	-	-	-							
	-	-	-							
				STRUCTURAL CONSULTANT Jehovaking Engineering Consultants Pvt. Ltd. 6th Cross Street, Lakshmi Nagar, Porur, Chennai - 600116						

FIRE FIGHTING LEGEND:-	
	100Ø FIRE HYDRANT PIPE
	DRAIN PIPE
	CO2 TYPE 4.5 KG FIRE EXTINGUISHER
	ABC TYPE 6KG FIRE EXTINGUISHER

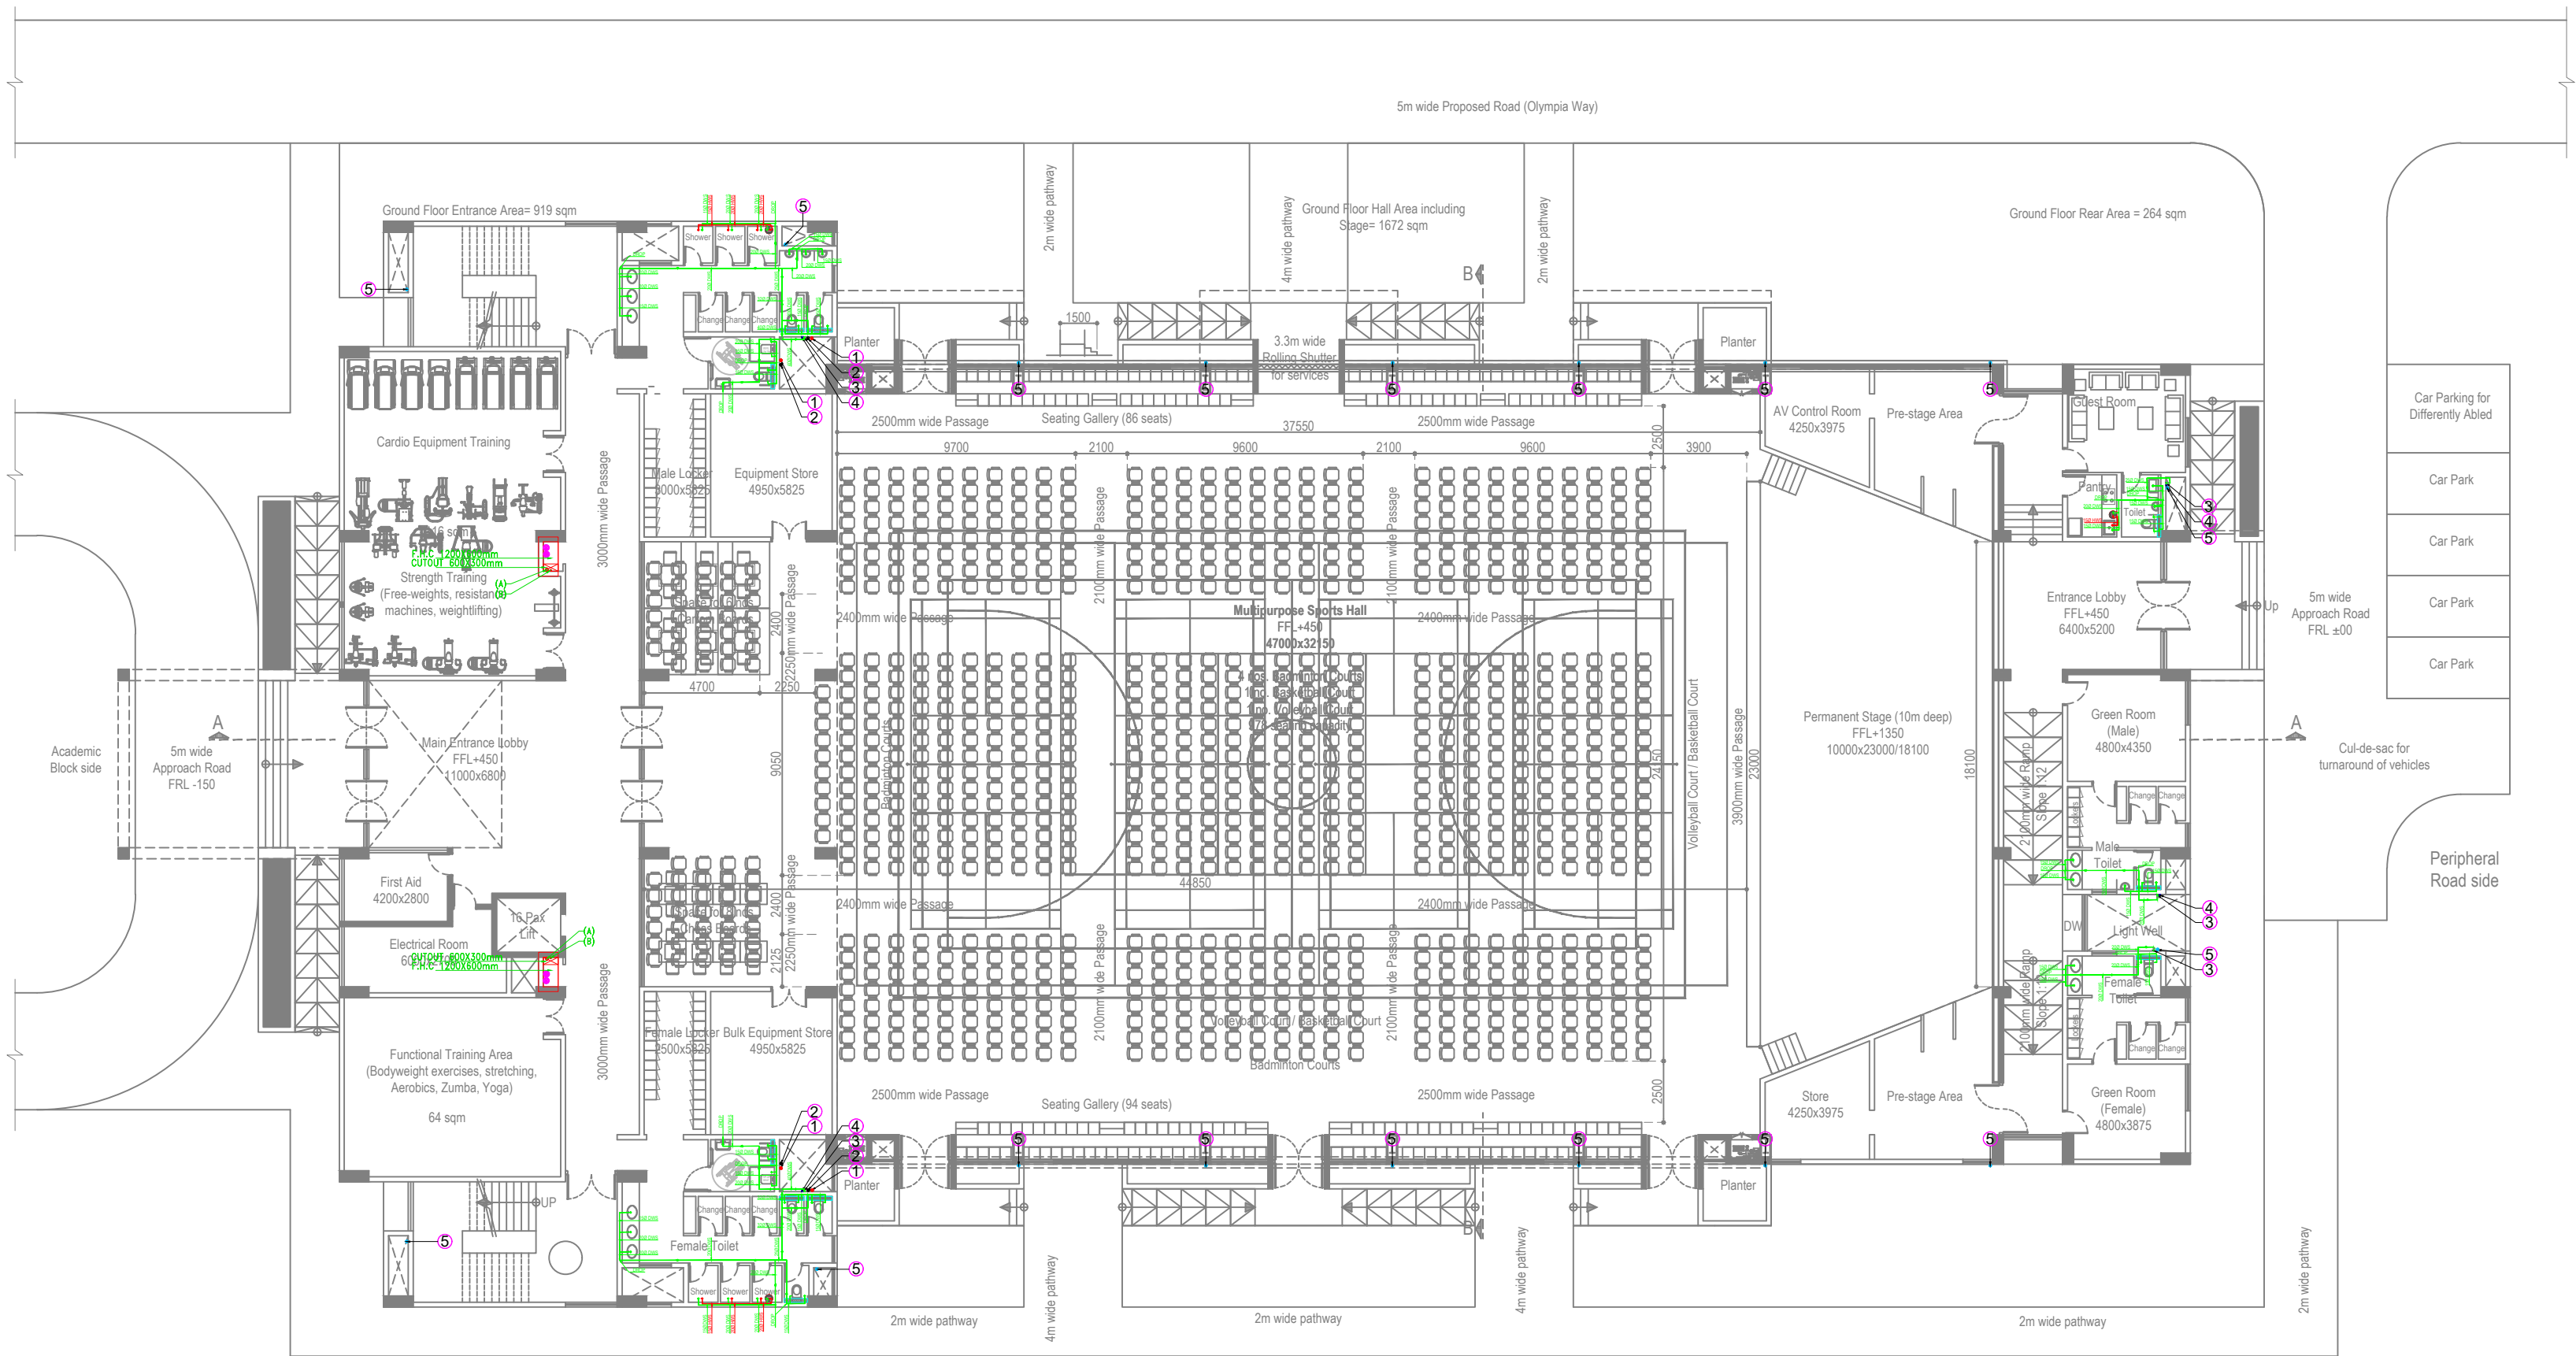

GROUND FLOOR PLAN

PLUMBING LEGEND:-	
(1)	110 OD uPVC SWR TYPE-B SOIL PIPE
(2)	110 OD uPVC SWR TYPE-B WASTE PIPE
(3)	D.W.S DOWN TAKE PIPE
(4)	D.W.S RISER PIPE TO OHT
(5)	110 OD uPVC RAIN WATER PIPE FOR TERRACE

PLUMBING NOTES:-	
1.	WASH BASIN TO FLOOR TRAP (FT) 40 OD WASTE PIPE
2.	MULTI TRAP TO FLOOR TRAP 50 OD WASTE PIPE
3.	KITCHEN SINK TO FLOOR TRAP (FT) 50 OD WASTE PIPE
4.	110 Od uPVC PIPE TO BE USE FOR SOIL & WASTE LINE.
5.	110 Od Upvc 6 kg/cm2 PIPE USED FOR TERRACE RAIN WATER.
6.	90 Od Upvc 6 kg/cm2 PIPE USED FOR TERRACE RAIN WATER.
FT	 FLOOR TRAP(110X110MM)
FD	 FLOOR DRAIN (110X63MM)
UT	 URINAL TRAP DRAIN (110X110MM)
COP	CLEAN OUT PLUG

PLUMBING LEGEND:-	
	GULLY TRAP 300X300mm
	SEWER MANHOLE SIZE 600X600mm & 750X750mm
	STORM WATER CATCH BASIN SIZE 450X500mm & 600X600mm

DETAILED PLUMBING & FIREFIGHTING DRAWINGS (FOR TENDER)

NOTES:	REVISIONS:		
1. All dimensions are in mm unless noted otherwise.	SL.	DATE	DESCRIPTION
2. The dimensions are to be read and not scaled off the drawing.	-	-	-
3. Any discrepancy in the drawing shall be brought to the notice of the Architects.	-	-	-
4. This drawing is to be read in conjunction with other relevant drawings & specifications given in the tender document.	-	-	-
5. Only the latest revision of the drawings shall be considered valid for all purposes.	-	-	-

ELECTRICAL CONSULTANT SV Intense Engineering Infrastructure Pvt. Ltd. Velachery, Chennai - 600042	PLUMBING & FIRE FIGHTING CONSULTANT Behera Associates Pvt Ltd F-623A, Lado Sarai, Behind CNG Station, New Delhi	HVAC CONSULTANT Abid Husain Consultants LG-1&2, Jeevan Prakash Apartment, 16A, Okhla, New Delhi	STRUCTURAL CONSULTANT Jehovaking Engineering Consultants Pvt. Ltd. 6th Cross Street, Lakshmi Nagar, Porur, Chennai - 600116


PROJECT Infrastructure Development at IIIT Sri City Chittoor	CLIENT Indian Institute of Information Technology Sri City, Chittoor Andhra Pradesh
--	--

ARCHITECT  Aadharshila Designs Pvt. Ltd. B - 4/124, L. G. F., Safdarjung Enclave, New Delhi - 110029.Tel : +91 11 26100433 - 6, Fax : +91 11 26177678, E-mail : adpl@adpl.in	COPYRIGHT This drawing is the property of Aadharshila Designs Pvt. Ltd. It shall not be copied, used in any manner and handed over to any person or party without the prior permission of Aadharshila Designs Pvt. Ltd.
--	--

DRAWING TITLE Water Supply & Firefighting Layouts - Ground Floor Multipurpose Sports Block	DATE 13-06-2025	SCALE NTS @ A2	REV. R0
---	--------------------	-------------------	------------

DRAWING NO. IITS/MSB/TD/PLFF-102	
-------------------------------------	--

FIRE FIGHTING LEGEND:--	
	100ø FIRE HYDRANT PIPE
	DRAIN PIPE
	CO2 TYPE 4.5 KG FIRE EXTINGUISHER
	ABC TYPE 6KG FIRE EXTINGUISHER

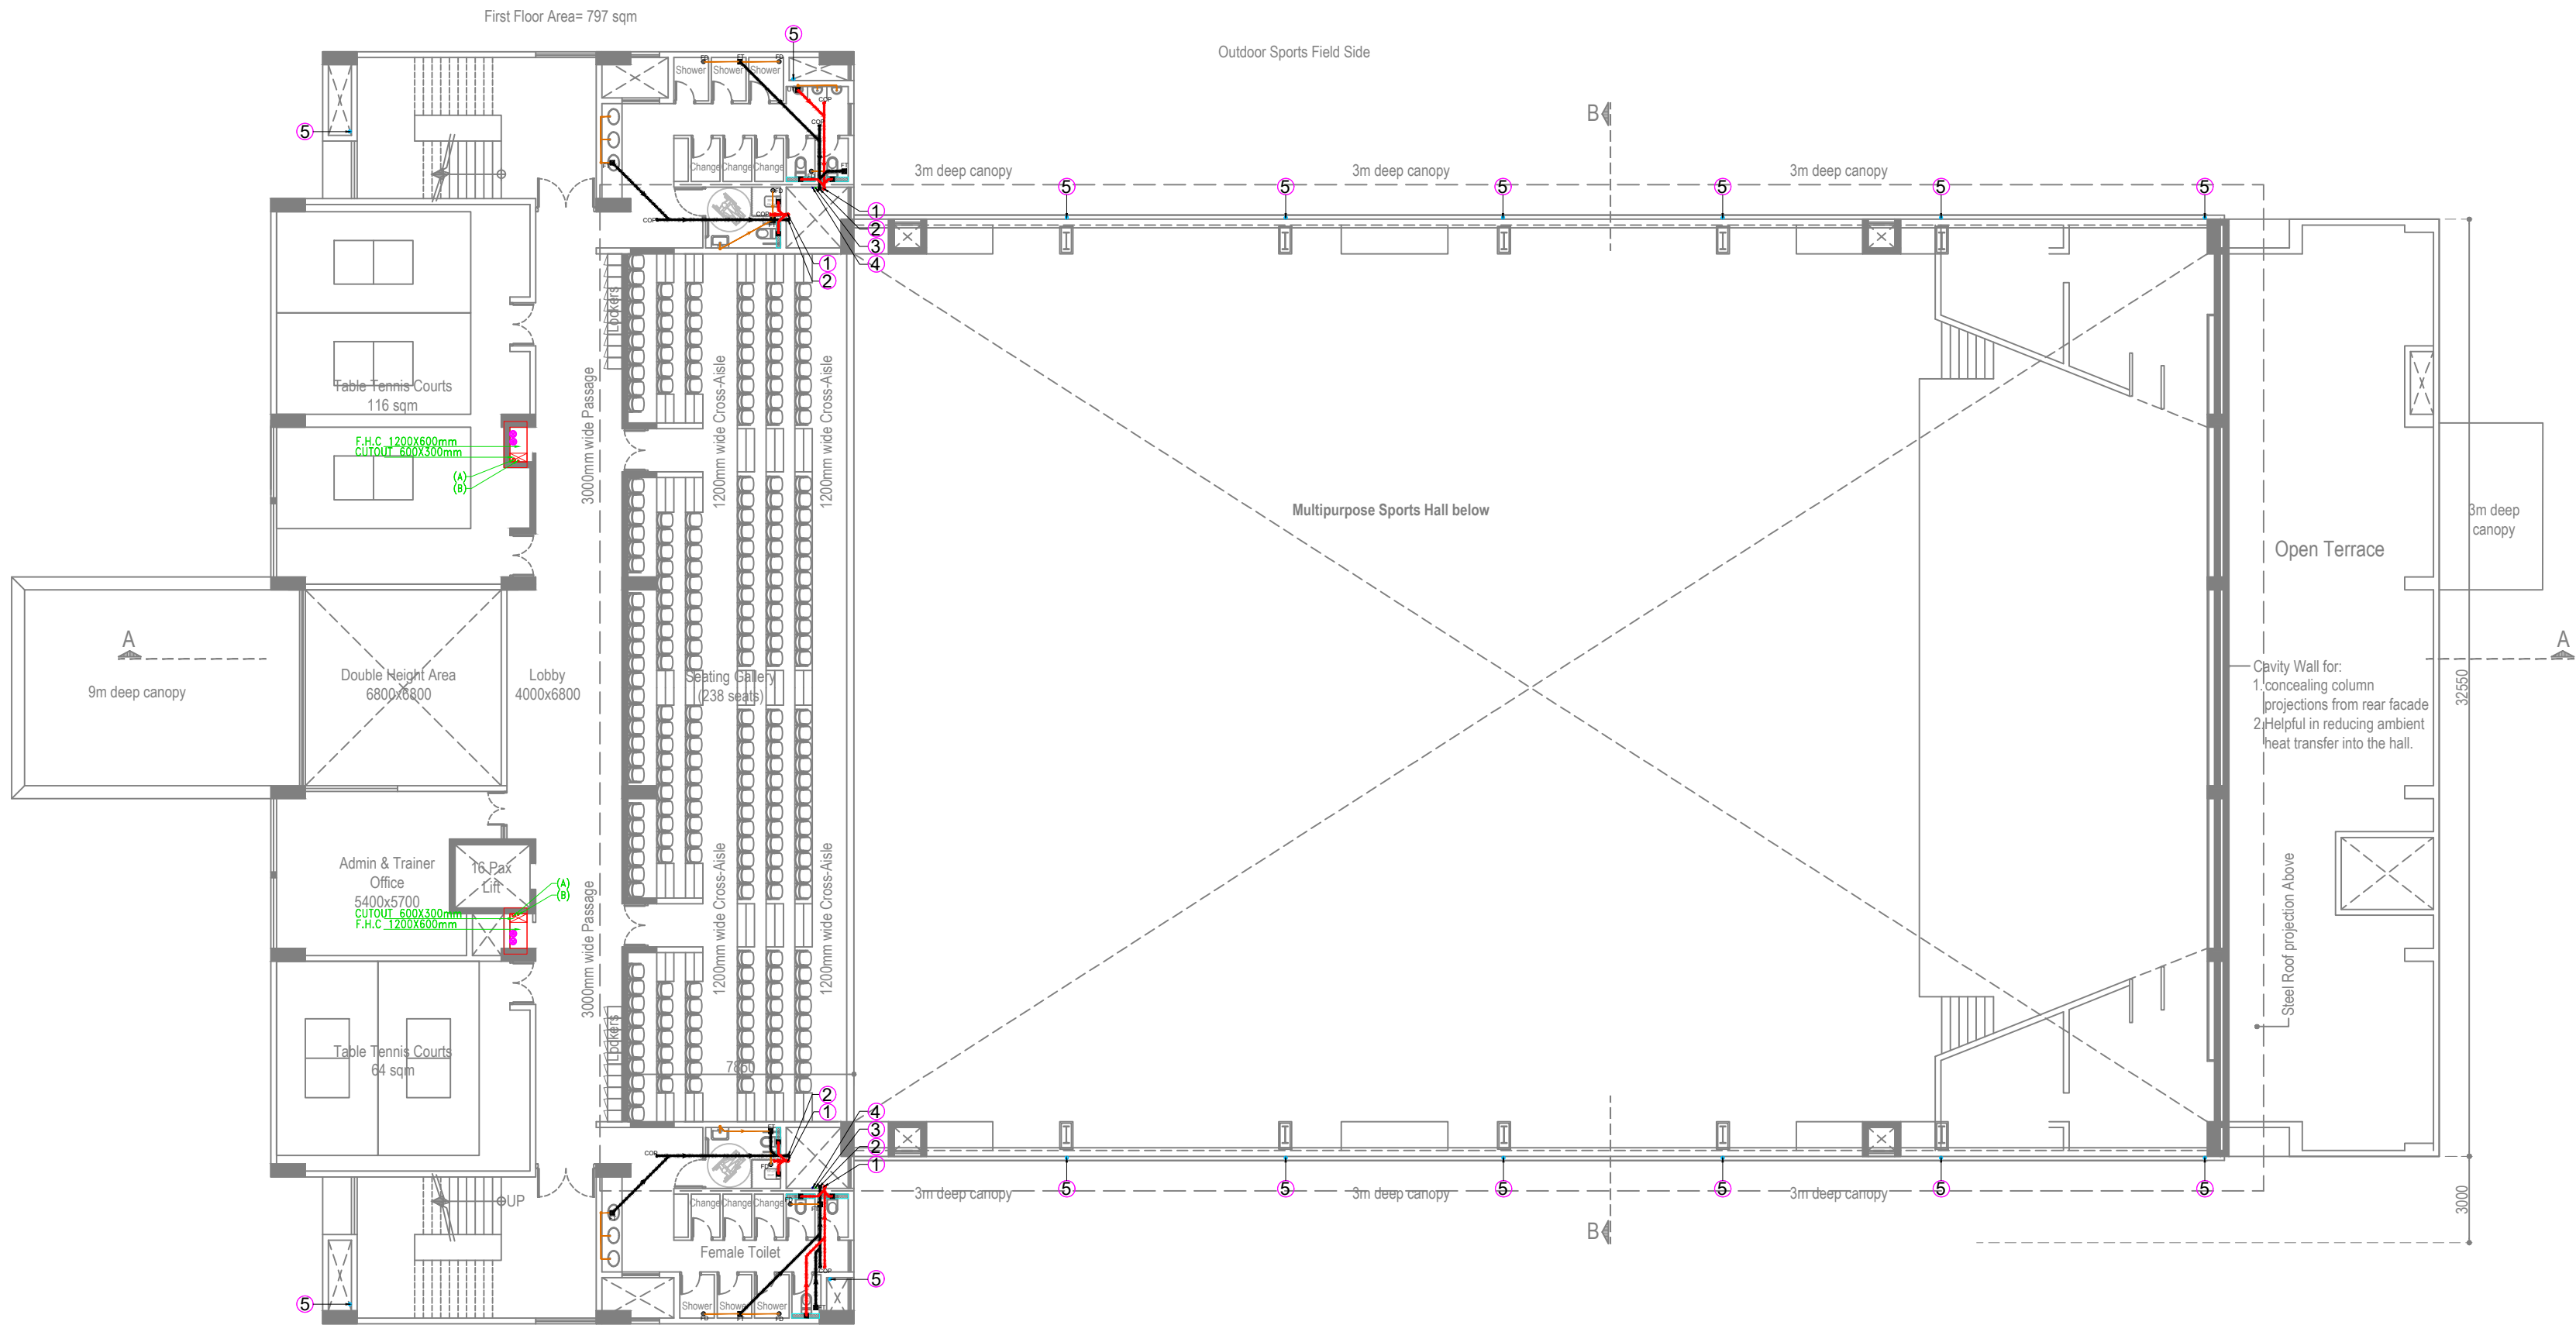


FIRST FLOOR PLAN

PLUMBING LEGEND:--	
(1)	110 OD uPVC SWR TYPE-B SOIL PIPE
(2)	110 OD uPVC SWR TYPE-B WASTE PIPE
(3)	D.W.S DOWN TAKE PIPE
(4)	D.W.S RISER PIPE TO OHT
(5)	110 OD uPVC RAIN WATER PIPE FOR TERRACE

PLUMBING NOTES:--		
1.	WASH BASIN TO FLOOR TRAP (FT) 40 OD WASTE PIPE	
2.	MULTI TRAP TO FLOOR TRAP 50 OD WASTE PIPE	
3.	KITCHEN SINK TO FLOOR TRAP (FT) 50 OD WASTE PIPE	
4.	110 Od uPVC PIPE TO BE USE FOR SOIL & WASTE LINE.	
5.	110 Od Upvc 6 kg/cm2 PIPE USED FOR TERRACE RAIN WATER.	
6.	90 Od Upvc 6 kg/cm2 PIPE USED FOR TERRACE RAIN WATER.	
FT		FLOOR TRAP(110X110MM)
FD		FLOOR DRAIN (110X63MM)
UT		URINAL TRAP DRAIN (110X110MM)
COP		CLEAN OUT PLUG

DETAILED PLUMBING & FIREFIGHTING DRAWINGS (FOR TENDER)

NOTES:		REVISIONS:			ELECTRICAL CONSULTANT SV Intense Engineering Infrastructure Pvt. Ltd. Velachery, Chennai - 600042		PROJECT		ARCHITECT		DRAWING TITLE		N	
1. All dimensions are in mm unless noted otherwise. 2. The dimensions are to be read and not scaled off the drawing. 3. Any discrepancy in the drawing shall be brought to the notice of the Architects. 4. This drawing is to be read in conjunction with other relevant drawings & specifications given in the tender document. 5. Only the latest revision of the drawings shall be considered valid for all purposes.		SL.	DATE	DESCRIPTION	PLUMBING & FIRE FIGHTING CONSULTANT Behera Associates Pvt Ltd F-623A, Lado Sarai, Behind CNG Station, New Delhi		Infrastructure Development at IIIT Sri City Chittoor		 Aadharshila Designs Pvt. Ltd.		Drainage & Firefighting Layouts - First Floor			
		-	-	-							Multipurpose Sports Block			
		-	-										REV.	
		-	-										R0	
		-	-											
		-	-											
-	-													
		-	-		HVAC CONSULTANT Abid Husain Consultants LG-1&2, Jeevan Prakash Apartment, 16A, Okhla, New Delhi		CLIENT Indian Institute of Information Technology Sri City, Chittoor Andhra Pradesh		B - 4/124, L. G. F., Safdarjung Enclave, New Delhi - 110029.Tel : +91 11 26100433 - 6, Fax : +91 11 26177678, E-mail : adpl@adpl.in		SCALE NTS @ A2			
		-	-		STRUCTURAL CONSULTANT Jehovaking Engineering Consultants Pvt. Ltd. 6th Cross Street, Lakshmi Nagar, Porur, Chennai - 600116				COPYRIGHT This drawing is the property of Aadharshila Designs Pvt. Ltd. It shall not be copied, used in any manner and handed over to any person or party without the prior permission of Aadharshila Designs Pvt. Ltd.		DRAWING NO. IITS/MSB/TD/PLFF-103			

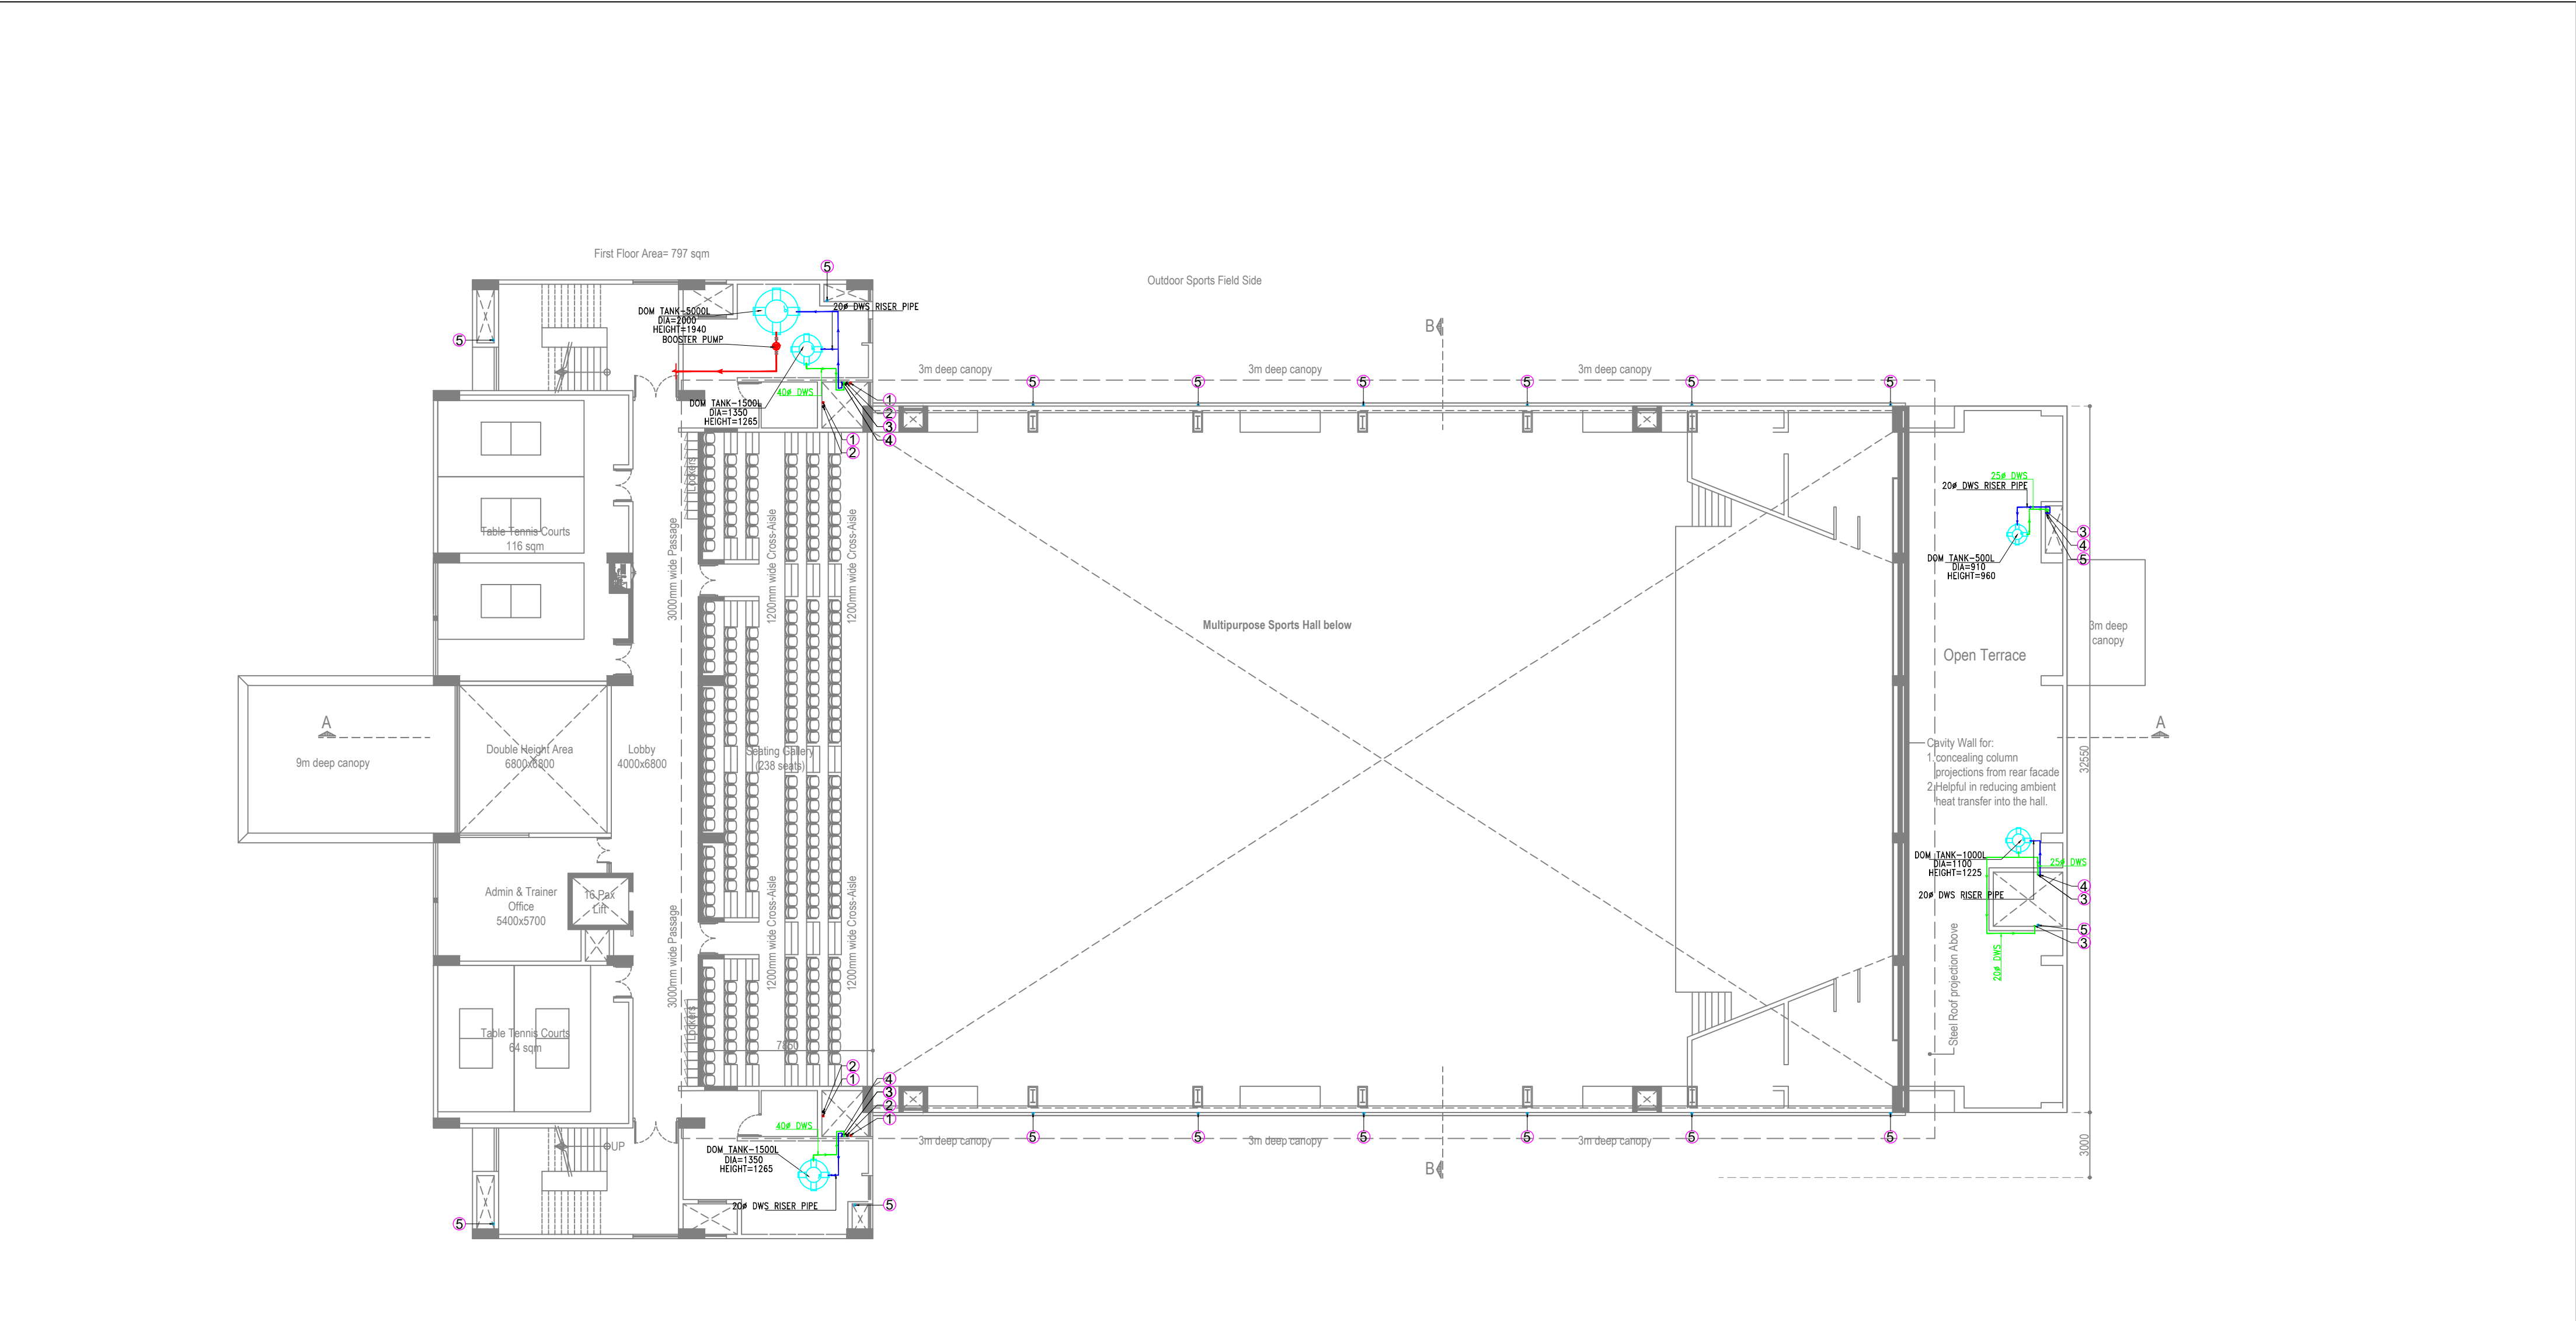

DETAILED PLUMBING & FIREFIGHTING DRAWINGS (FOR TENDER)

NOTES: 1. All dimensions are in mm unless noted otherwise. 2. The dimensions are to be read and not scaled off the drawing. 3. Any discrepancy in the drawing shall be brought to the notice of the Architects. 4. This drawing is to be read in conjunction with other relevant drawings & specifications given in the tender document. 5. Only the latest revision of the drawings shall be considered valid for all purposes.	REVISIONS:			ELECTRICAL CONSULTANT SV Intense Engineering Infrastructure Pvt. Ltd. Velachery, Chennai - 600042 PLUMBING & FIRE FIGHTING CONSULTANT Behera Associates Pvt Ltd F-623A, Lado Sarai, Behind CNG Station, New Delhi HVAC CONSULTANT Abid Husain Consultants LG-1&2, Jeevan Prakash Apartment, 16A, Okhla, New Delhi STRUCTURAL CONSULTANT Jehovaking Engineering Consultants Pvt. Ltd. 6th Cross Street, Lakshmi Nagar, Porur, Chennai - 600116	PROJECT Infrastructure Development at IIIT Sri City Chittoor CLIENT Indian Institute of Information Technology Sri City, Chittoor Andhra Pradesh	ARCHITECT Aadharshila Designs Pvt. Ltd. B - 4/124, L. G. F., Safdarjung Enclave, New Delhi - 110029.Tel : +91 11 26100433 - 6, Fax : +91 11 26177678, E-mail : adpl@adpl.in COPYRIGHT This drawing is the property of Aadharshila Designs Pvt. Ltd. It shall not be copied, used in any manner and handed over to any person or party without the prior permission of Aadharshila Designs Pvt. Ltd.	DRAWING TITLE Water Supply Layout - Terrace Floor Multipurpose Sports Block		N R0
	SL.	DATE	DESCRIPTION				DATE 13-06-2025	SCALE NTS @ A2	
	-	-	-						
	-	-	-						
	-	-	-						